


Not For Construction

CONSULTANTS
Heapy Engineering
MEP Design Technology Planning Commissioning Energy
Nationally Recognized Leader in Sustainability
1400 W Dorothy Lane, Dayton, OH 45409-1310
Ph 937-224-0661 Fax 937-224-5777 www.heapy.com


DAYTON CONVENTION CENTER
NEUTRAL ANALYSIS
OWNER
DAYTON CONVENTION & VISITORS BUREAU
1 CHAMBER PLAZA, SUITE A
DAYTON, OHIO 45402

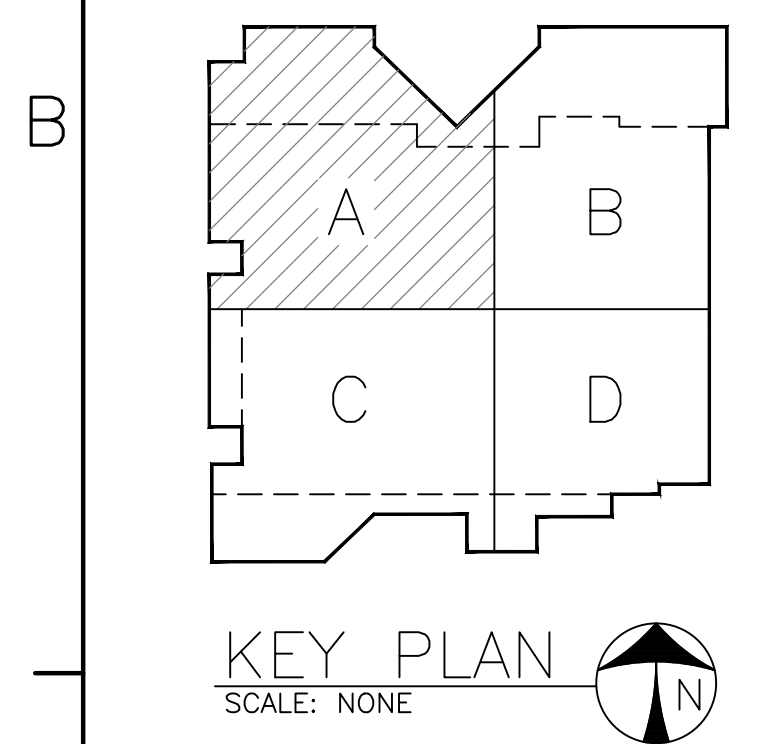

PROJECT NO:	2017-07081
CAD DWG FILE:	E1.1 FIRST FLOOR PLAN - AREA A.DWG
DRAWN BY:	-
CHK'D BY:	-
COPYRIGHT:	-

SHEET TITLE
FIRST FLOOR PLAN - AREA A

SHEET
E1.1

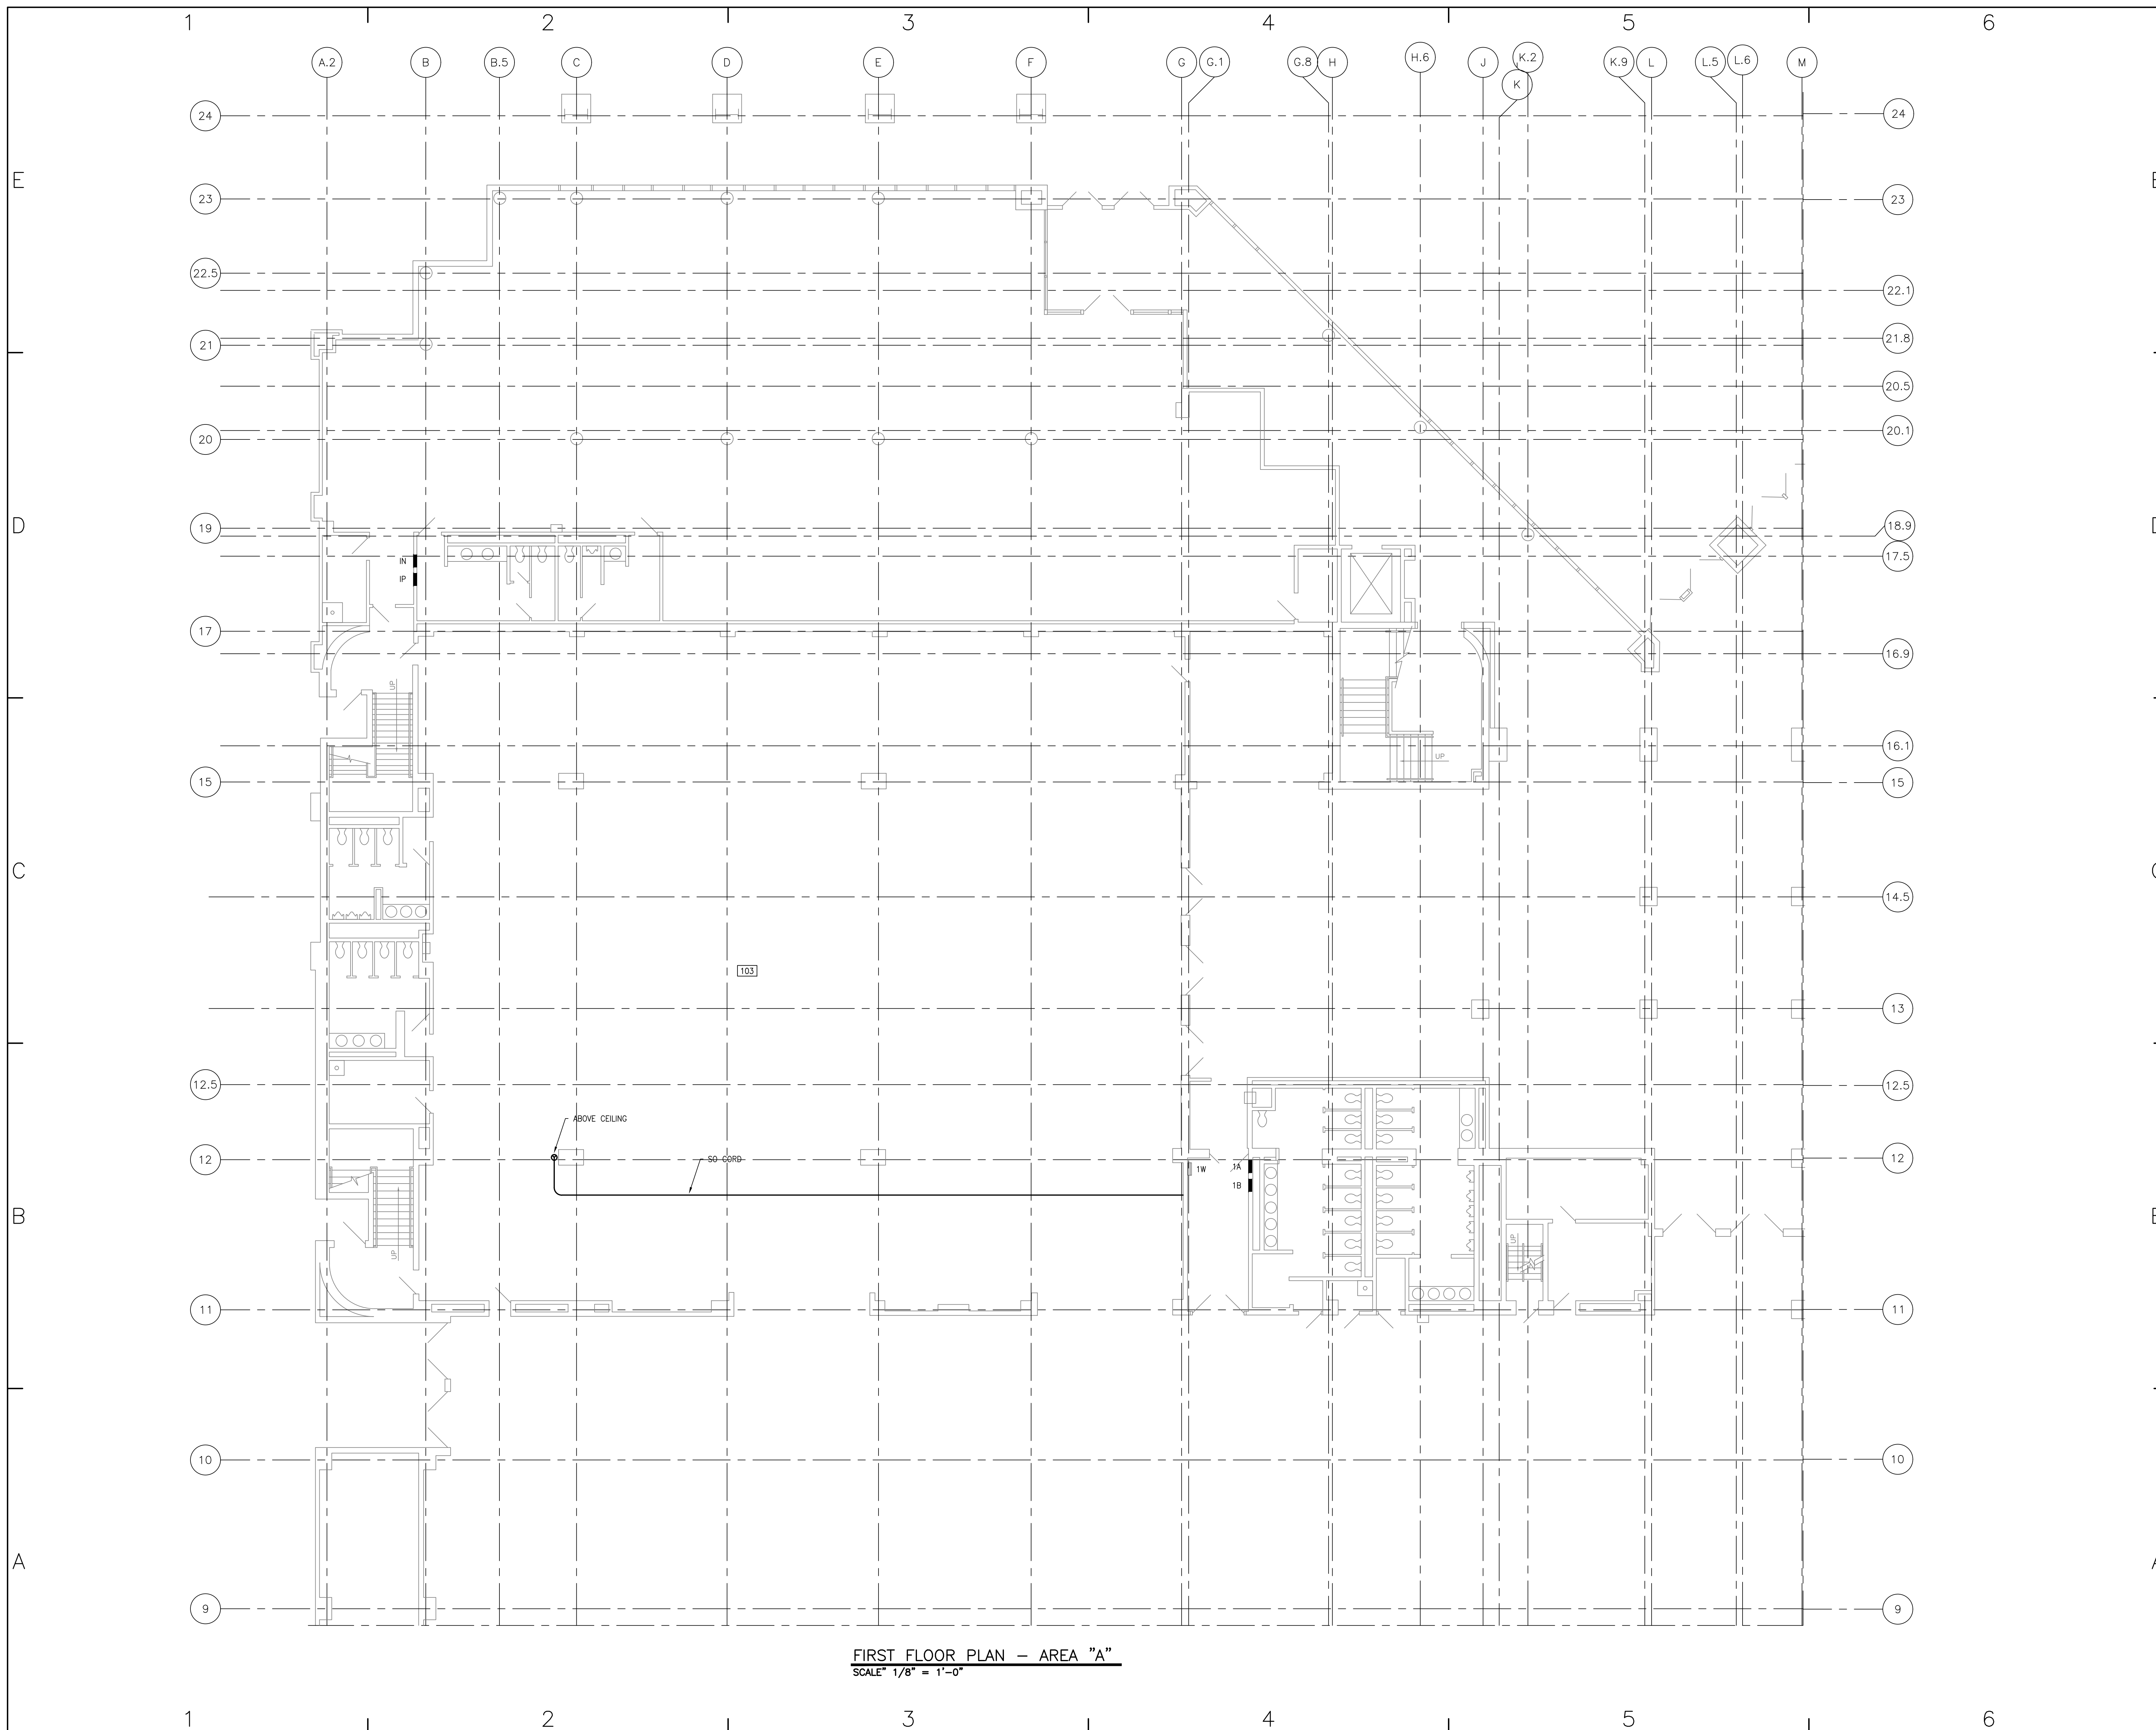

FIRST FLOOR PLAN - AREA "A"
SCALE: 1/8" = 1'-0"

PROJECT NO: 2017-07081
DATE: December 20, 2017
HEAPY ENGINEERING
DAYTON/COLUMBUS, OHIO & INDIANAPOLIS, INDIANA
MECHANICAL ELECTRICAL COMMISSIONING TECHNOLOGY


Not For Construction

CONSULTANTS

Heapy Engineering
 MEP Design Technology Planning Commissioning Energy
 Nationally Recognized Leader in Sustainability
 1400 W Dorothy Lane, Dayton, OH 45409-1310
 Ph 937-224-0661 Fax 937-224-5777 www.heapy.com

DAYTON CONVENTION CENTER
NEUTRAL ANALYSIS

OWNER
DAYTON CONVENTION & VISITORS BUREAU
1 CHAMBER PLAZA, SUITE A
DAYTON, OHIO 45402

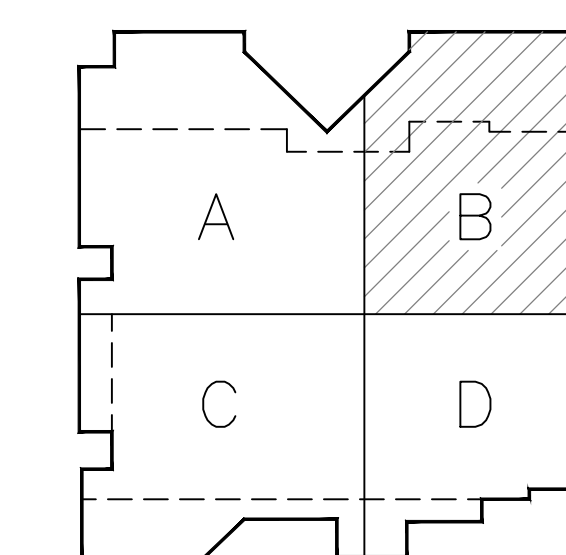


KEY PLAN
SCALE: NONE

NO.	DATE	DESCRIPTION
12/21/17		DOCUMENT SET
MARK	DATE	DESCRIPTION
PROJECT NO:	2017-07081	
CAD DWG FILE:	E1.2 FIRST FLOOR PLAN - AREA B.DWG	
DRAWN BY:	-	
CHK'D BY:	-	
COPYRIGHT:	-	

SHEET TITLE
FIRST FLOOR PLAN - AREA B

SHEET E1.2

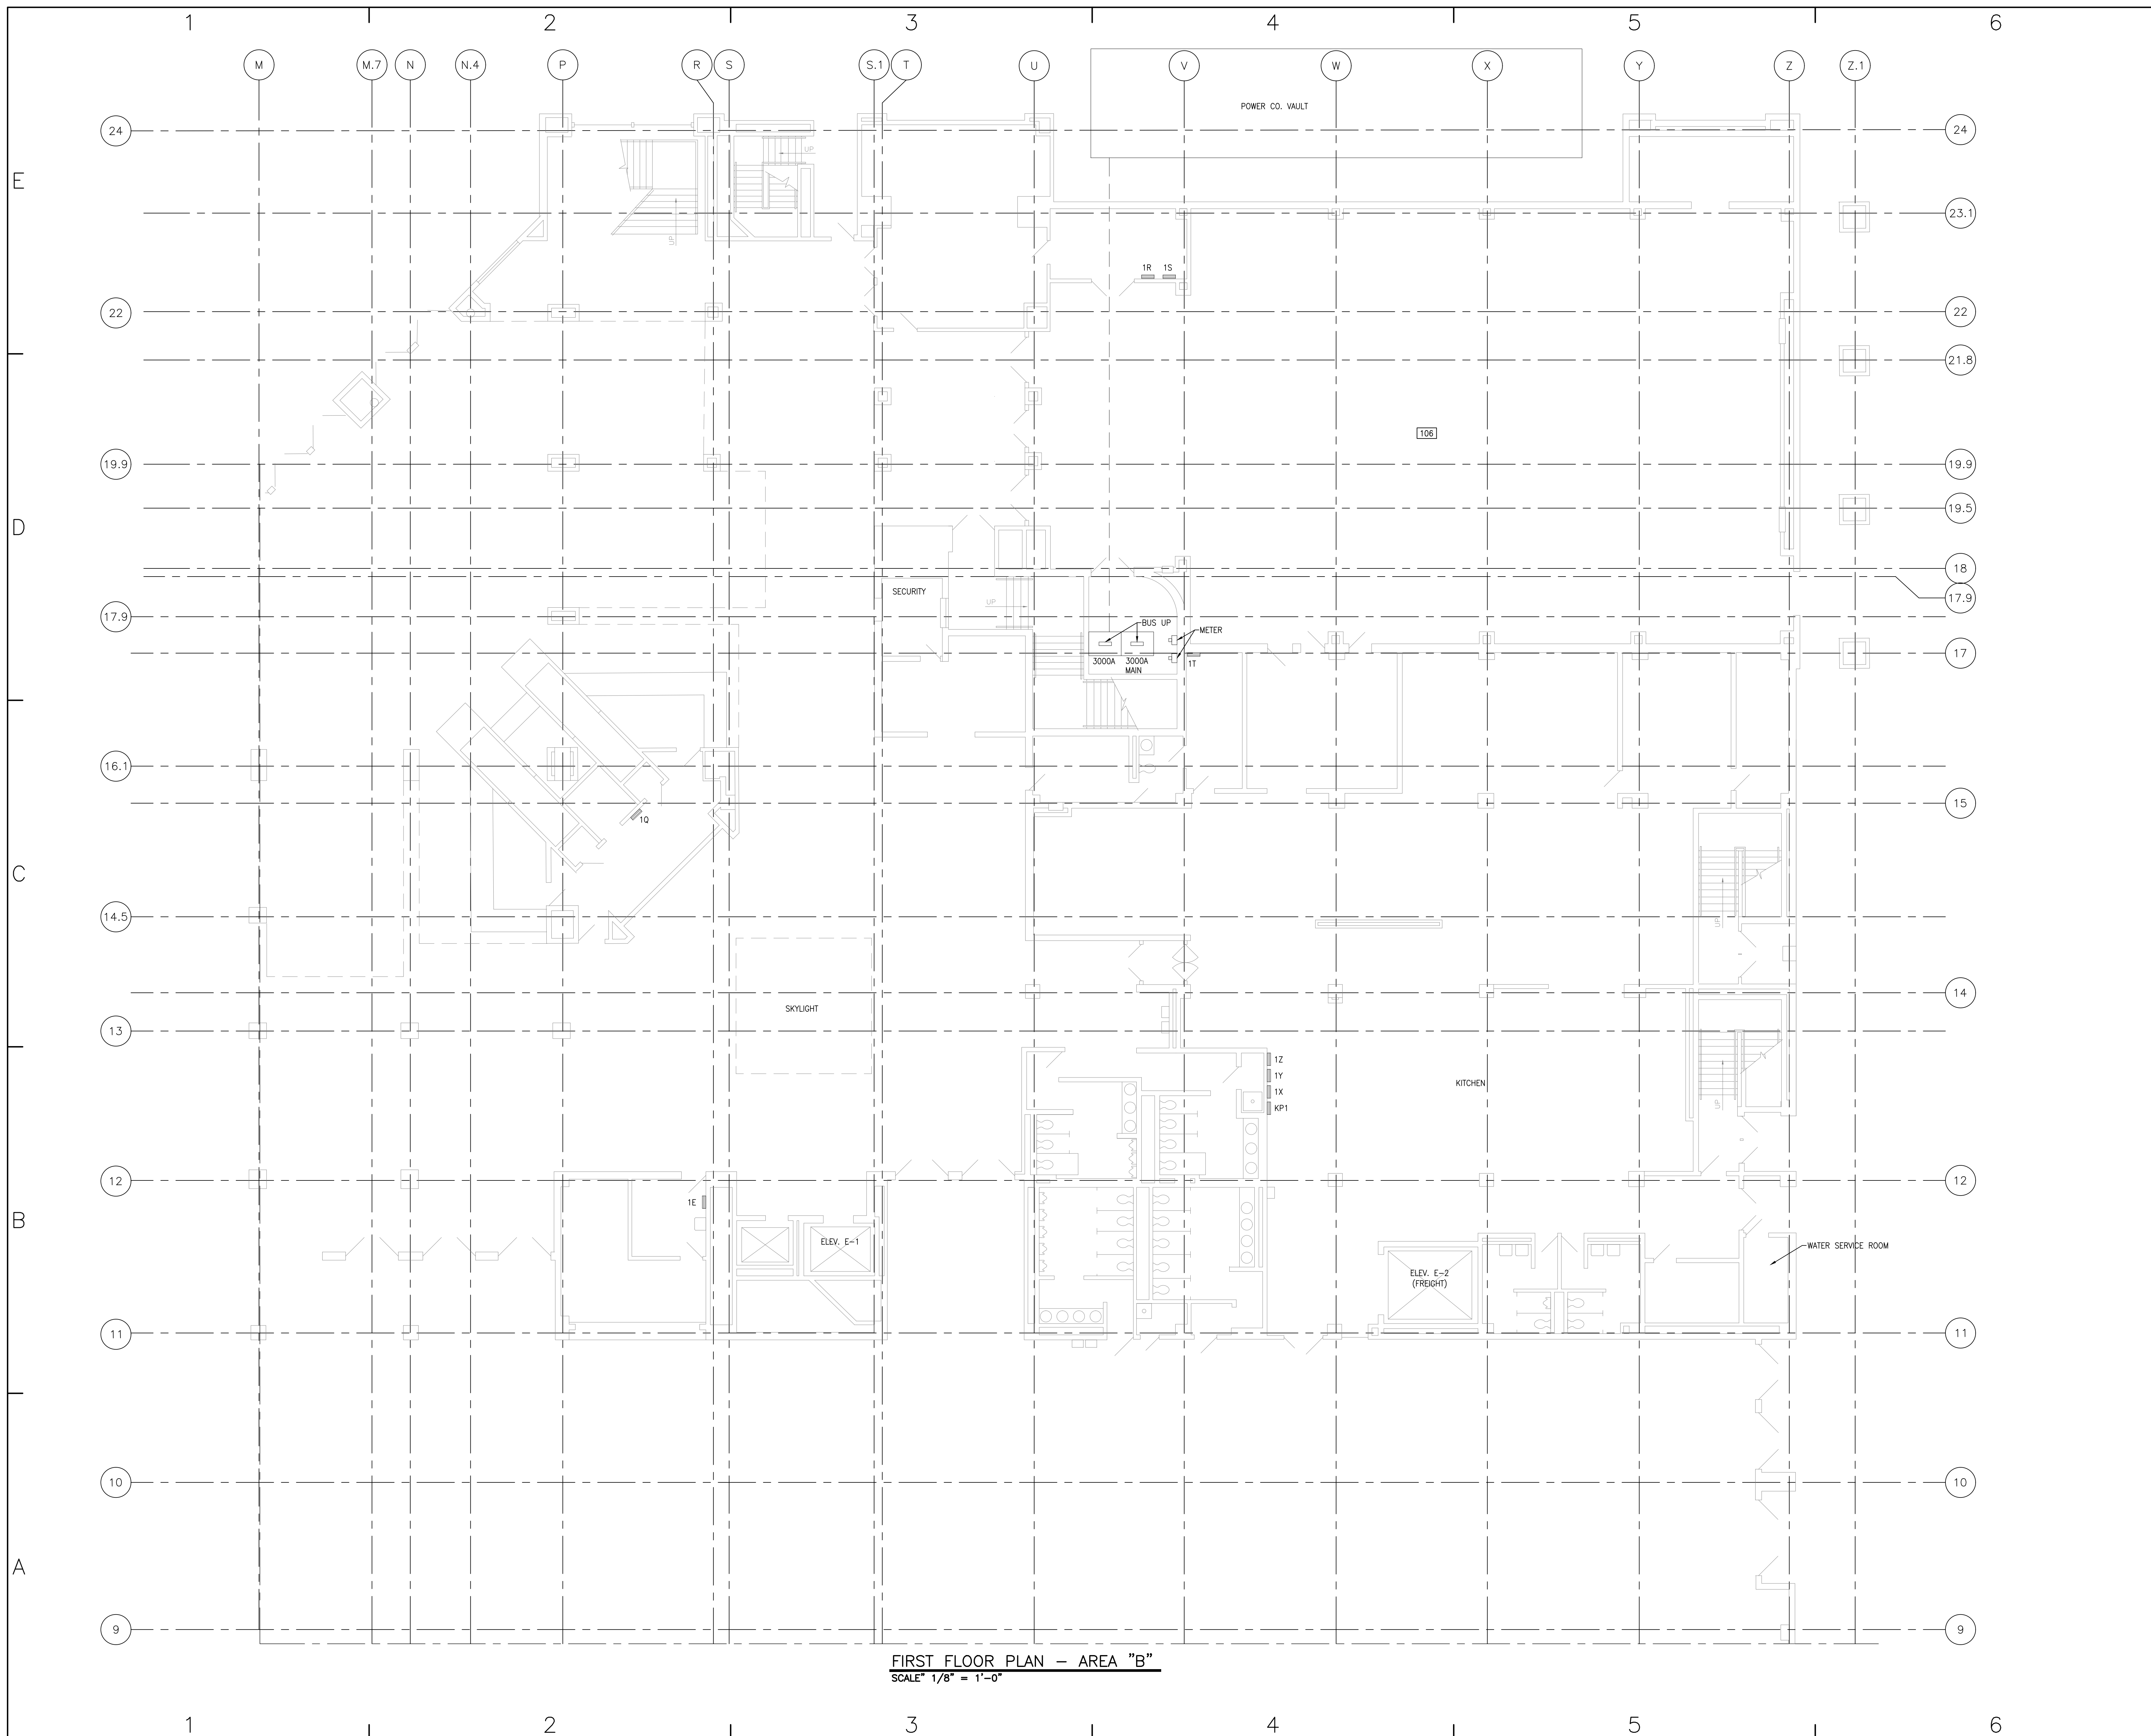

FIRST FLOOR PLAN - AREA "B"
SCALE 1/8" = 1'-0"

PROJECT NO. 2017-07081
 HEAPY ENGINEERING
 DAYTON/COLUMBUS, OHIO & INDIANAPOLIS, INDIANA
 MECHANICAL ELECTRICAL COMMISSIONING TECHNOLOGY


Not For Construction

CONSULTANTS

Heapy Engineering
MEP Design Technology Planning Commissioning Energy
Nationally Recognized Leader in Sustainability
1400 W Dorothy Lane, Dayton, OH 45409-1310
Ph 937-224-0661 Fax 937-224-5777 www.heapy.com

DAYTON CONVENTION CENTER
NEUTRAL ANALYSIS

OWNER
DAYTON CONVENTION &
VISITORS BUREAU
1 CHAMBER PLAZA, SUITE A
DAYTON, OHIO 45402

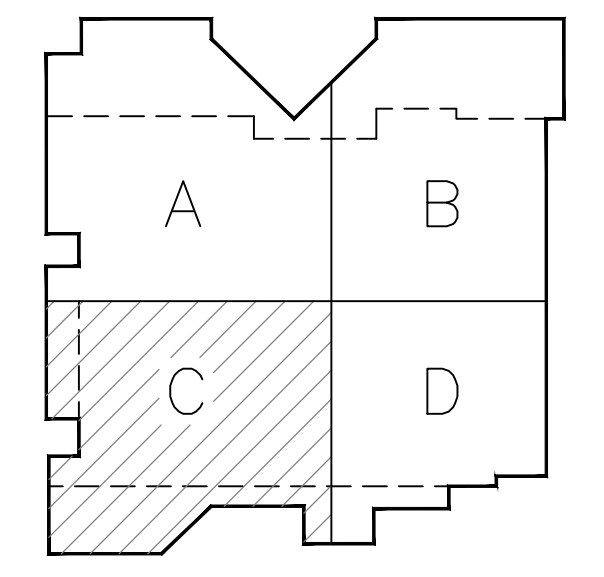


KEY PLAN
SCALE: NONE

PROJECT NO:	2017-07081
CAD DWG FILE:	E1.3 FIRST FLOOR PLAN - AREA C.DWG
DRAWN BY:	-
CHK'D BY:	-
COPYRIGHT:	-

SHEET TITLE
FIRST FLOOR PLAN - AREA C


SHEET
E1.3

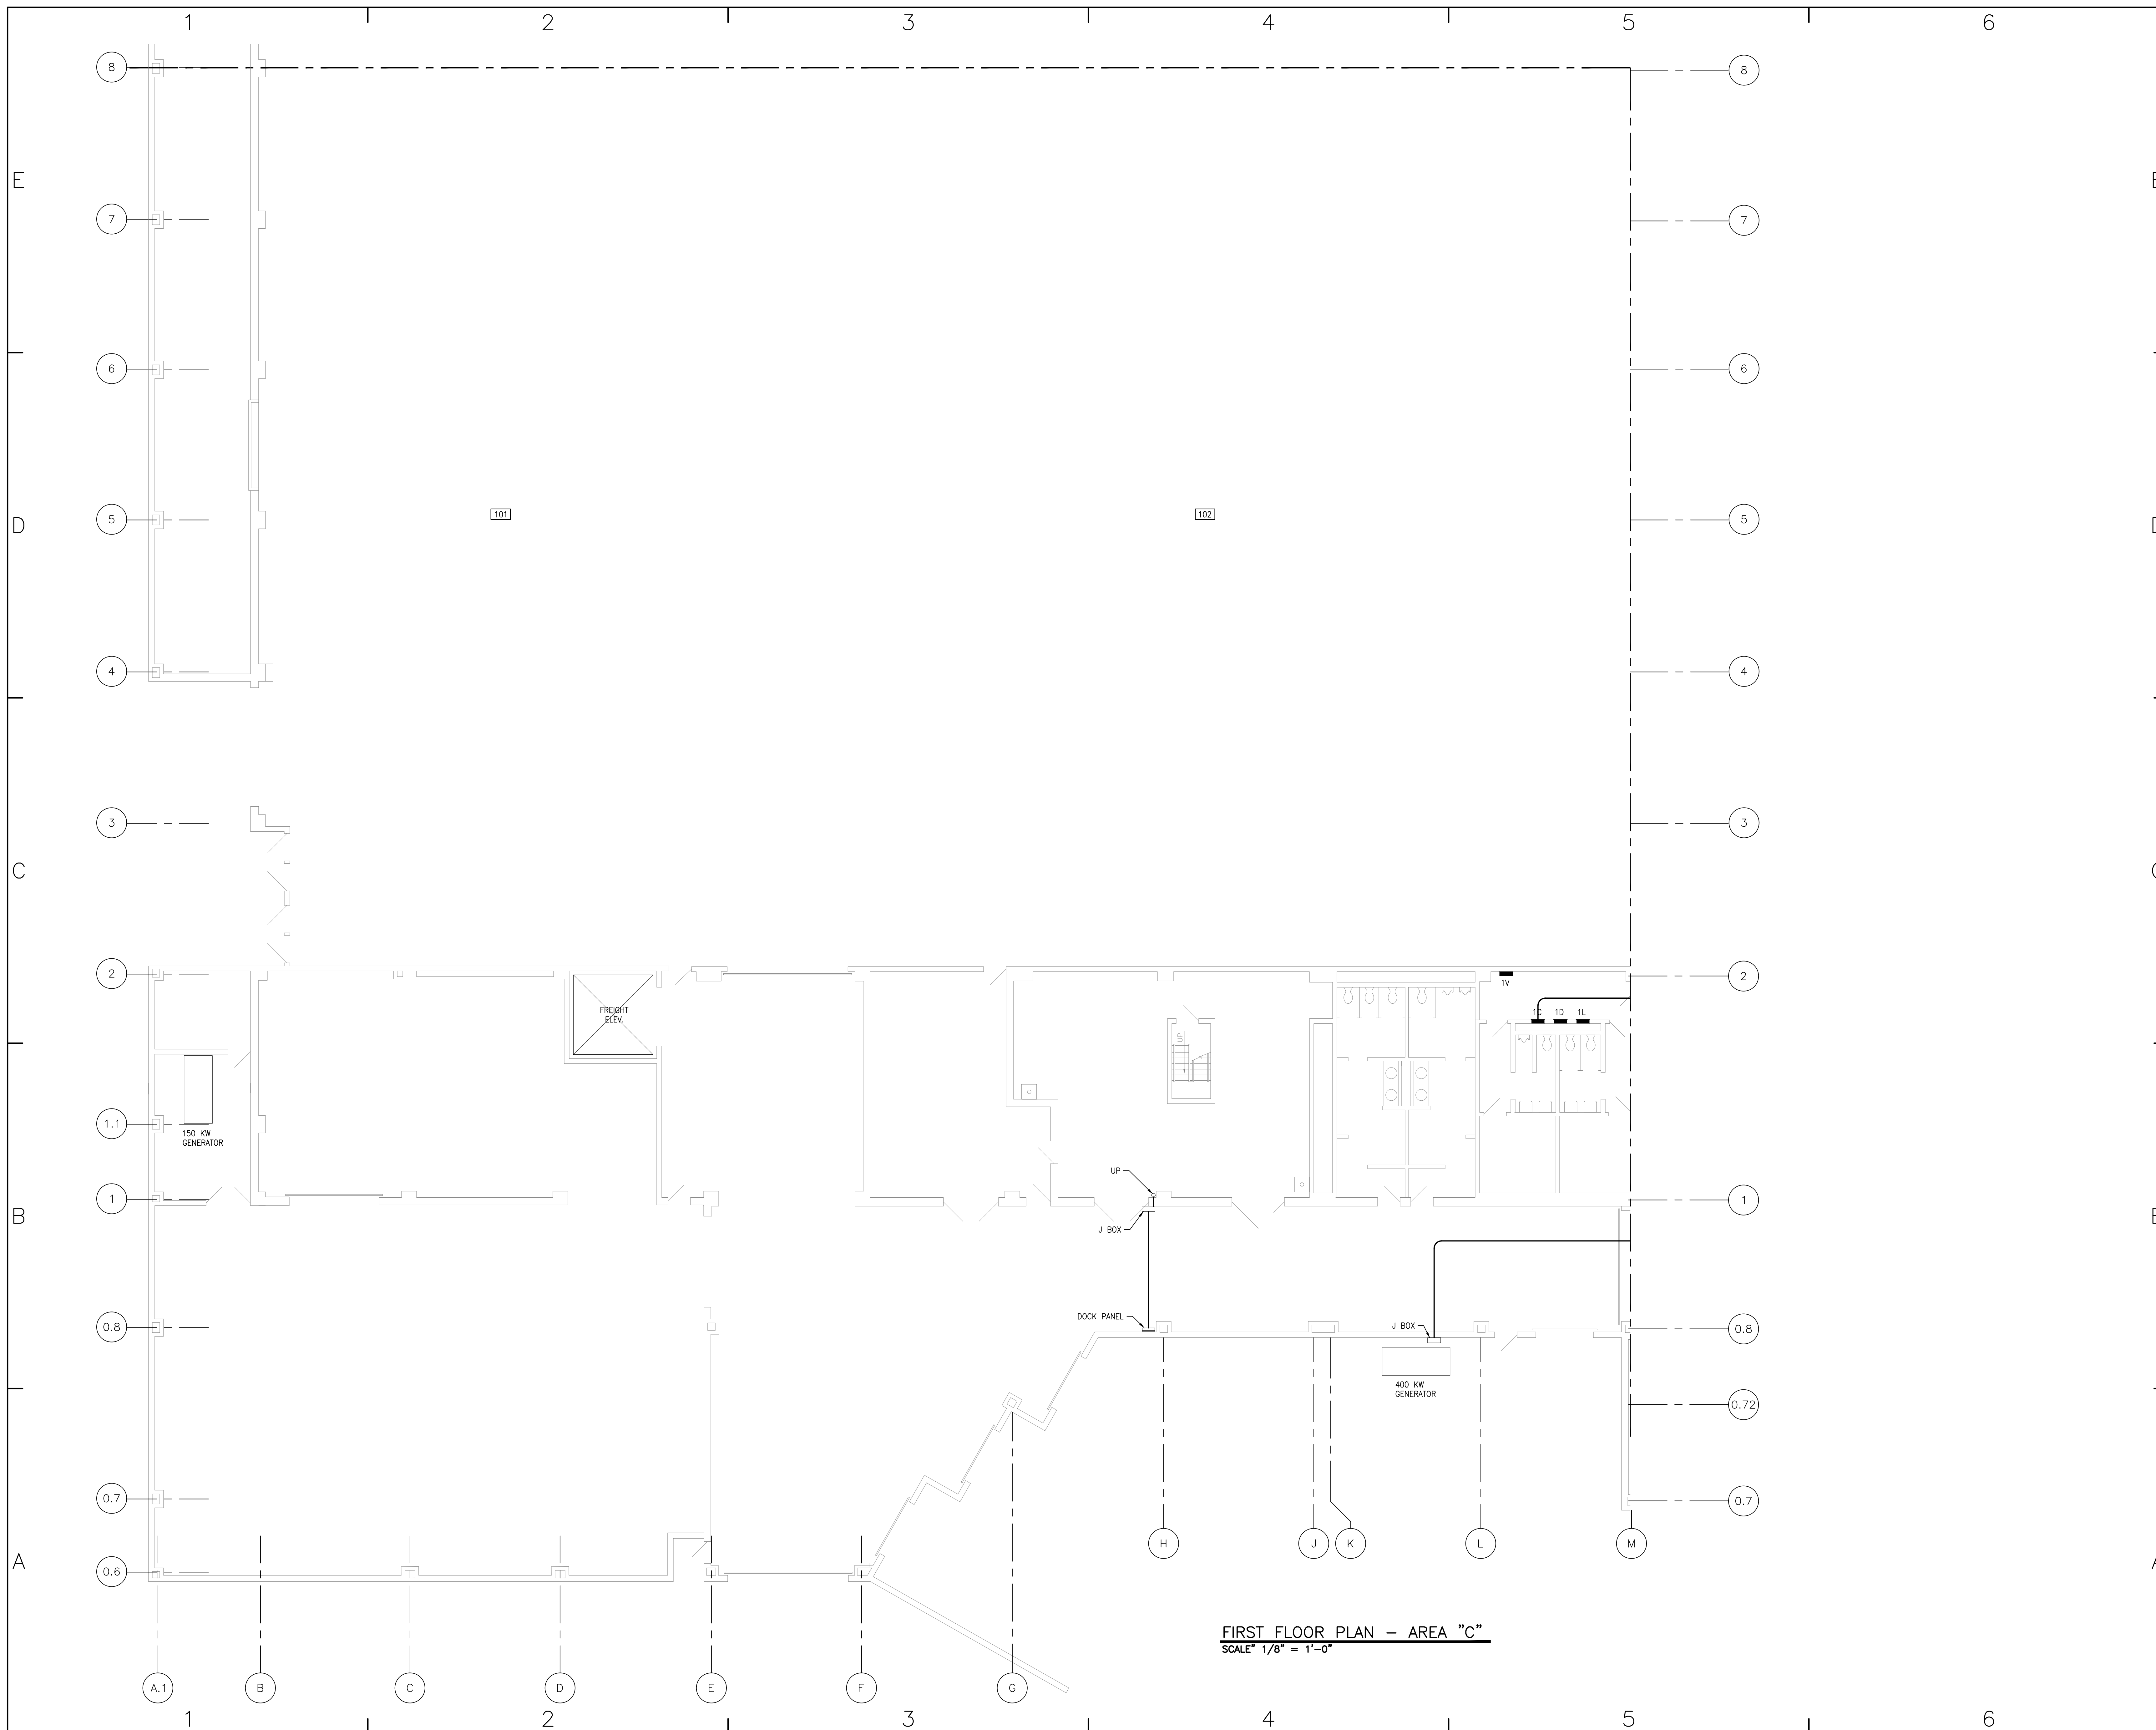

PROJECT NO. 2017-07081
HEAPY ENGINEERING
DAYTON/COLUMBUS, OHIO & INDIANAPOLIS, INDIANA
MECHANICAL ELECTRICAL COMMISSIONING TECHNOLOGY

DATE: December 20, 2017
PLOT/EDP DATE: December 20, 2017

PROJECT NO. 2017-0781
 HEAPY ENGINEERING
 DAYTON/COLUMBUS, OHIO & INDIANAPOLIS, INDIANA
 MECHANICAL ELECTRICAL COMMISSIONING TECHNOLOGY

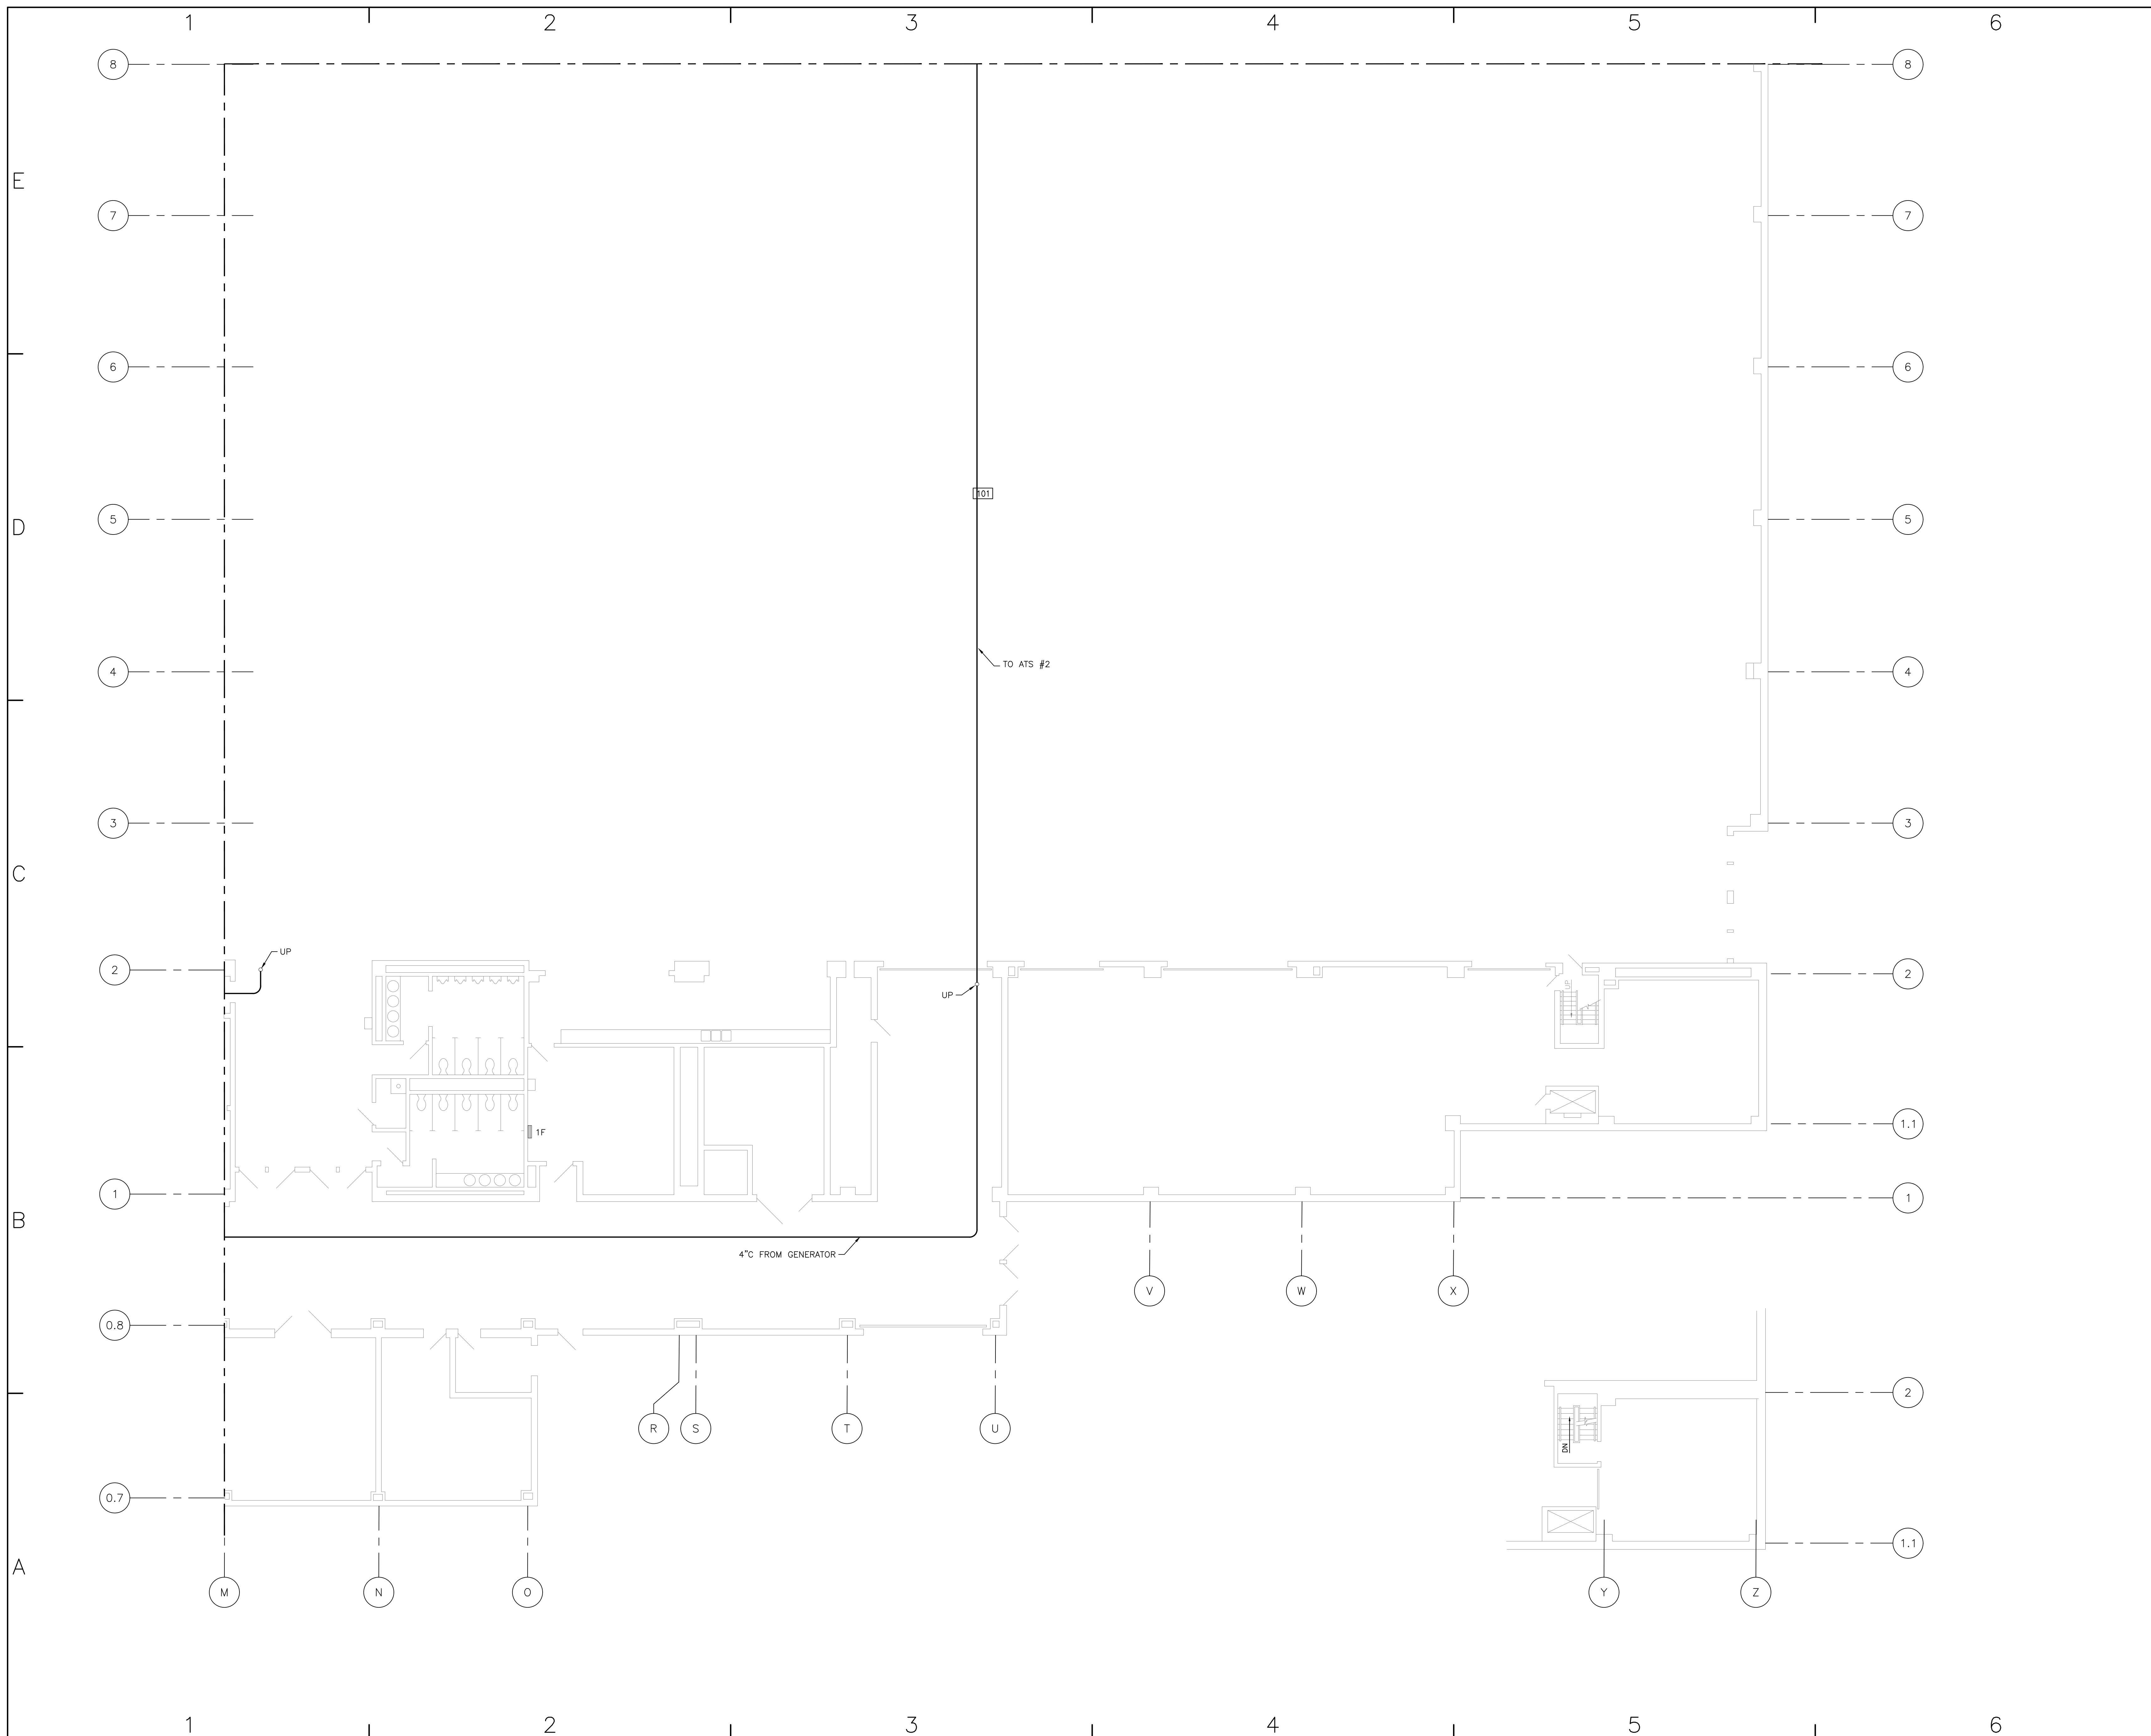


Not For Construction

CONSULTANTS

Heapy Engineering
 MEP Design Technology Planning Commissioning Energy
Nationally Recognized Leader in Sustainability
 1400 W Dorothy Lane, Dayton, OH 45409-1310
 Ph 937-224-0661 Fax 937-224-5777 www.heapy.com

DAYTON CONVENTION CENTER
 NEUTRAL ANALYSIS

OWNER
 DAYTON CONVENTION & VISITORS BUREAU
 1 CHAMBER PLAZA, SUITE A
 DAYTON, OHIO 45402

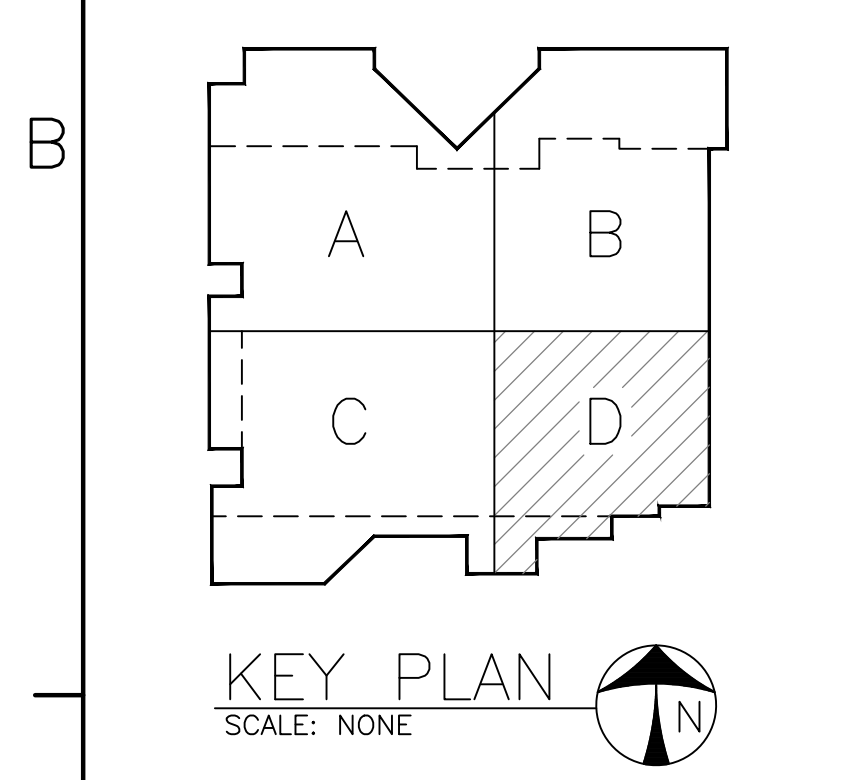


MARK	DATE	DESCRIPTION
	12/21/17	DOCUMENT SET

PROJECT NO: 2017-0781
 CAD DWG FILE: E1.4 FIRST FLOOR PLAN - AREA D.DWG
 DRAWN BY: -
 CHK'D BY: -

COPYRIGHT:
 SHEET TITLE
FIRST FLOOR PLAN - AREA D

SHEET **E1.4**

Not For Construction

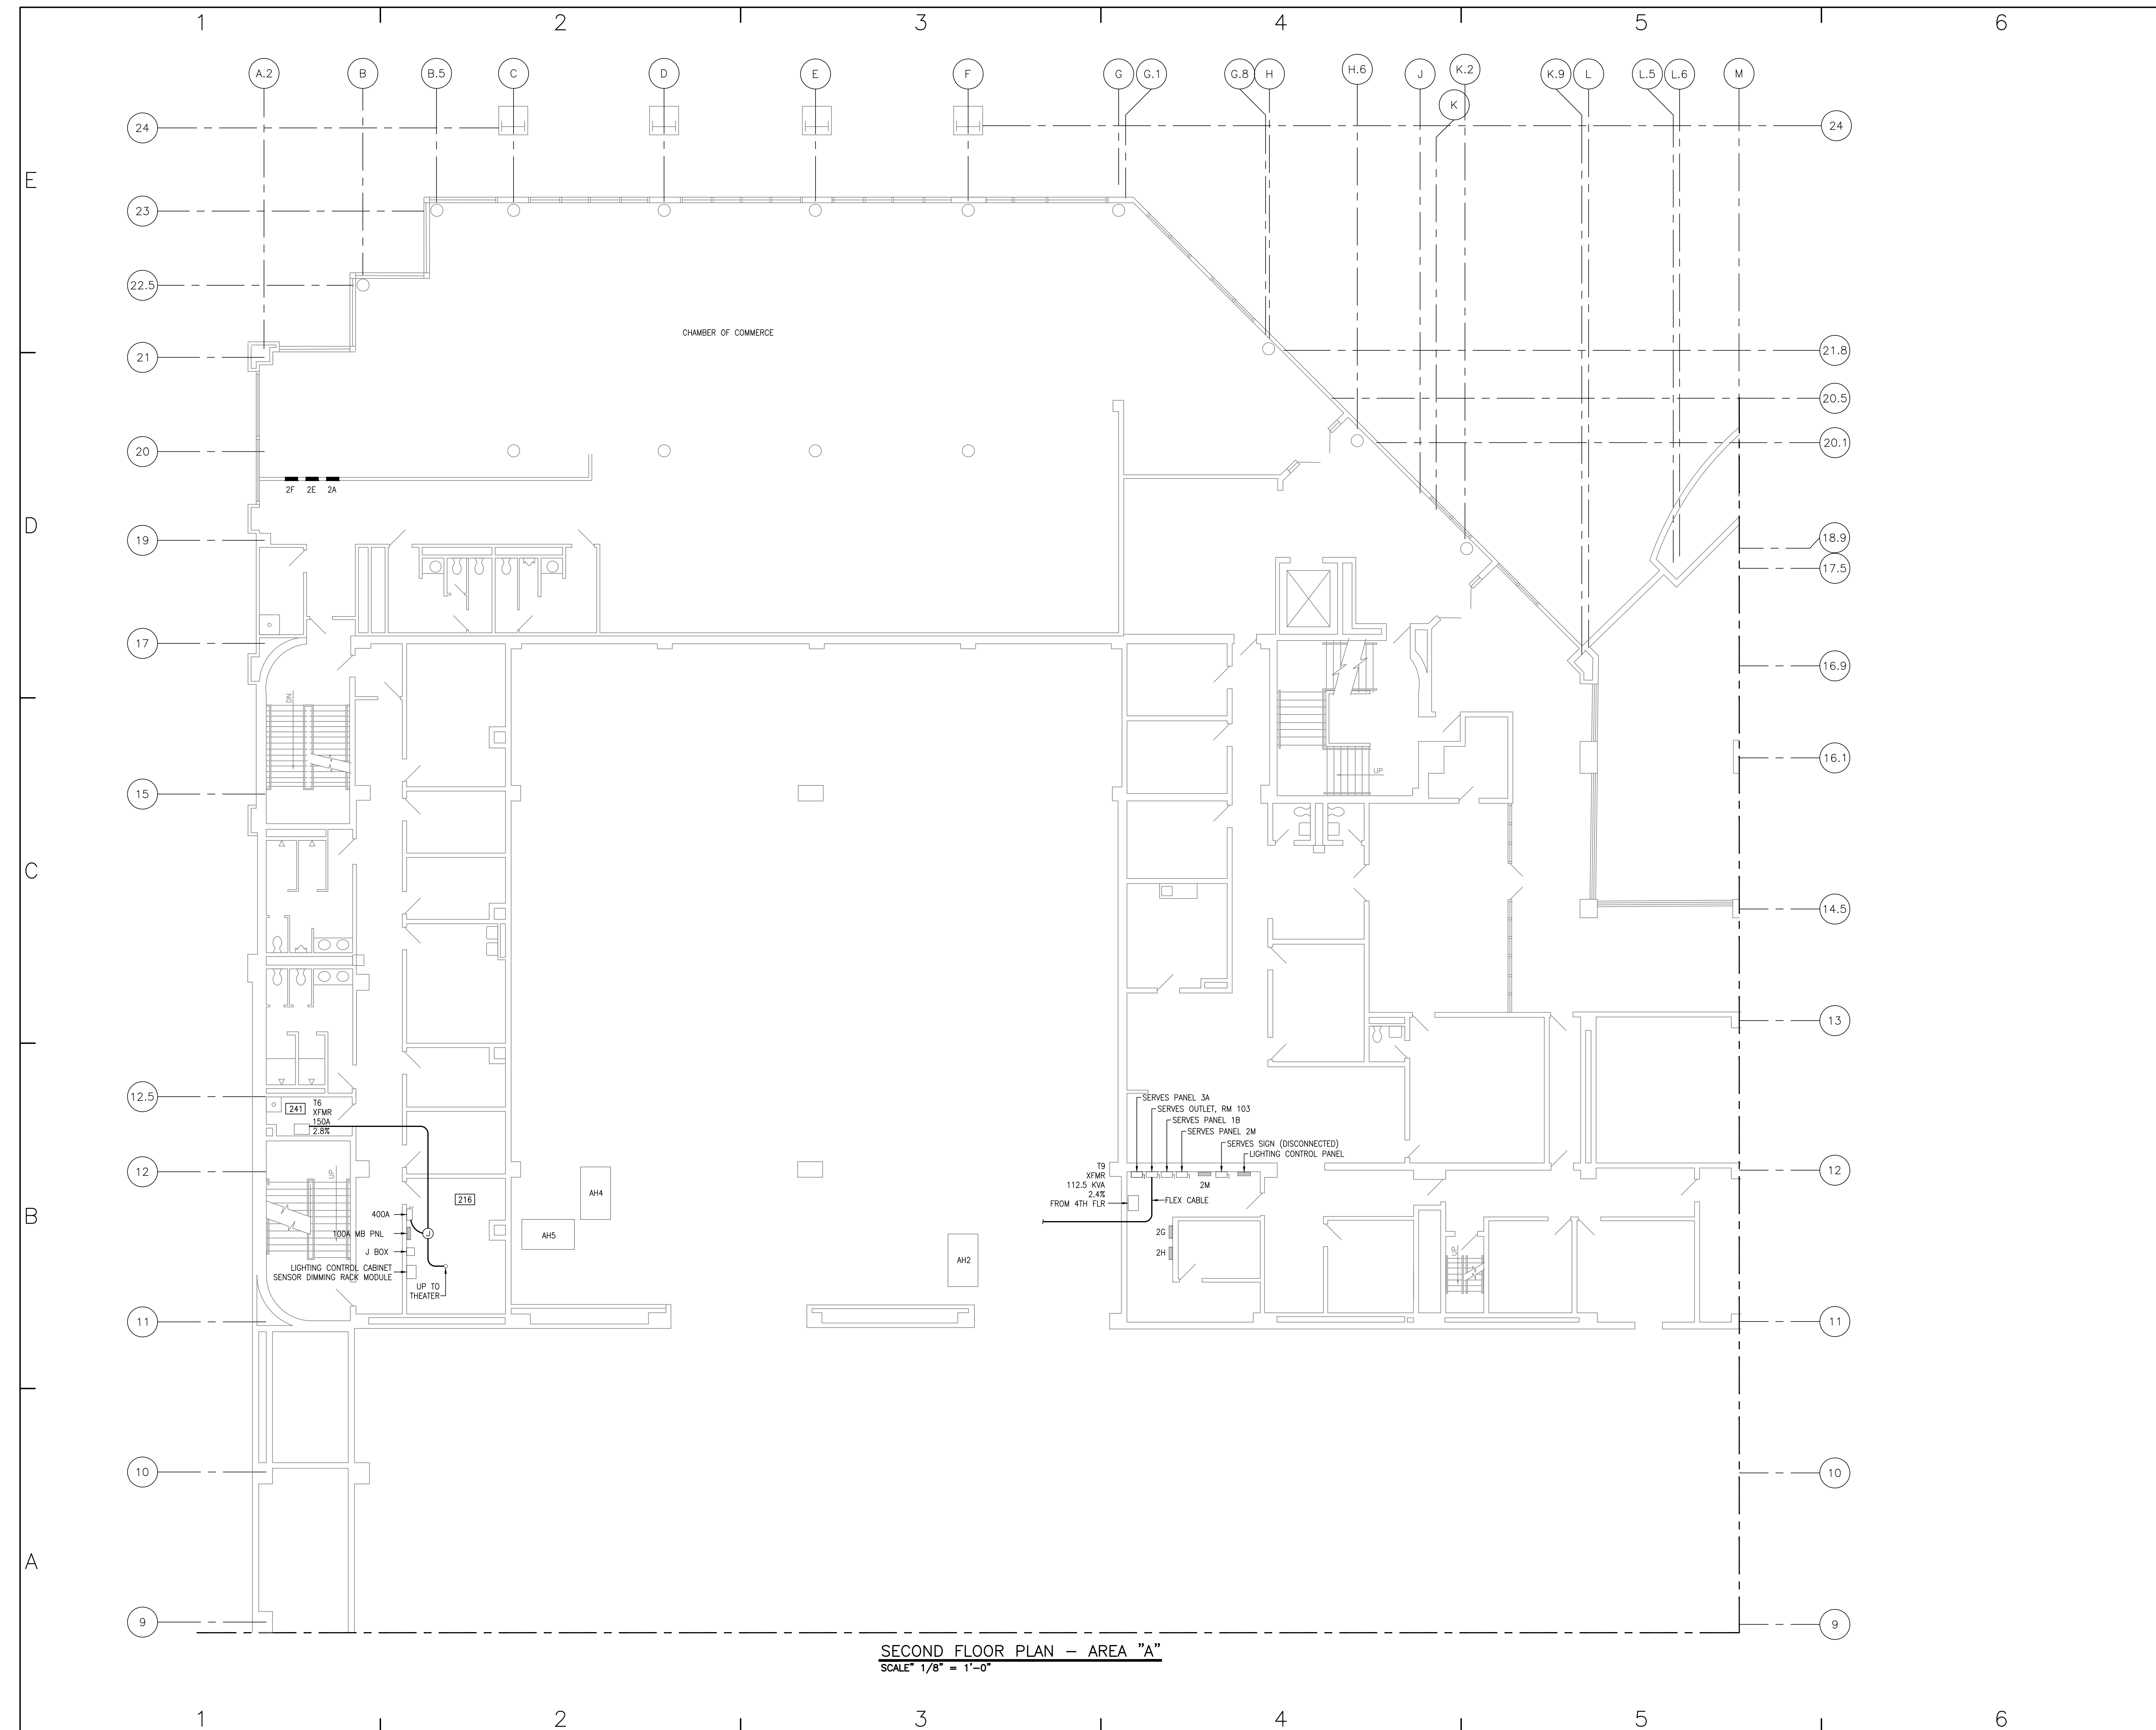


SECOND FLOOR PLAN - AREA "A"
SCALE: 1/8" = 1'-0"

CONSULTANTS

Heapy Engineering
MEP Design Technology Planning Commissioning Energy
Nationally Recognized Leader in Sustainability
1400 W Dorothy Lane, Dayton, OH 45409-1310
Ph 937-224-0661 Fax 937-224-5777 www.heapy.com

DAYTON CONVENTION CENTER
NEUTRAL ANALYSIS

OWNER
DAYTON CONVENTION &
VISITORS BUREAU
1 CHAMBER PLAZA, SUITE A
DAYTON, OHIO 45402

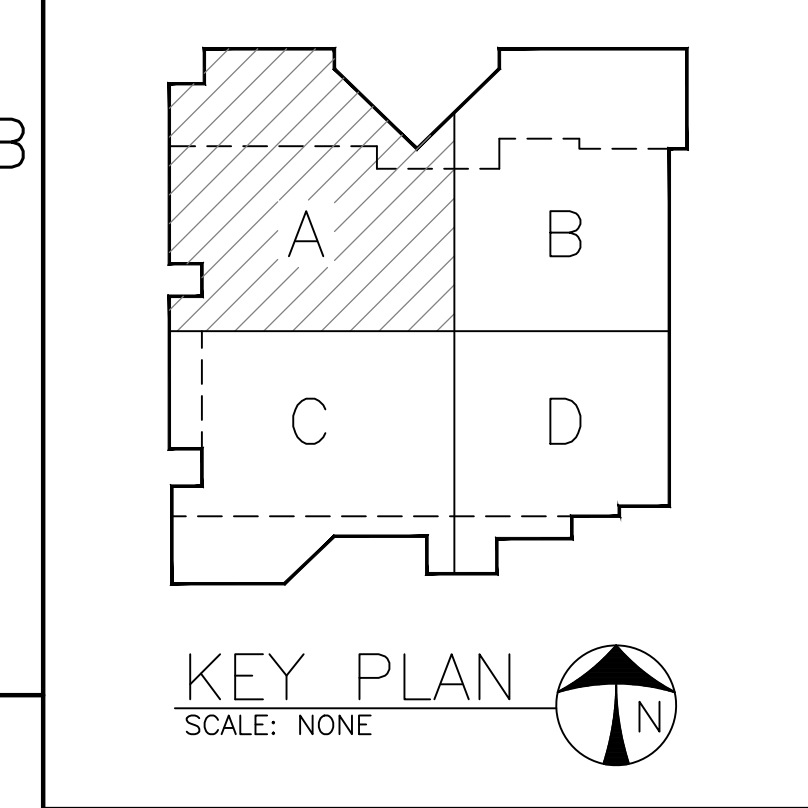

MARK	DATE	DESCRIPTION
	12/21/17	DOCUMENT SET
PROJECT NO:	2017-07081	
CAD DWG FILE:	E2.1 SECOND FLOOR PLAN - AREA A.DWG	
DRAWN BY:	-	
CHK'D BY:	-	
COPYRIGHT:	-	

SHEET TITLE
SECOND FLOOR PLAN - AREA A

PROJECT NO: 2017-07081
HEAPY ENGINEERING
DAYTON/COLUMBUS, OHIO & INDIANAPOLIS, INDIANA
MECHANICAL ELECTRICAL COMMISSIONING TECHNOLOGY

DATE PLOTTED: December 20, 2017


Not For Construction

CONSULTANTS

Heapy Engineering
MEP Design Technology Planning Commissioning Energy
Nationally Recognized Leader in Sustainability
1400 W Dorothy Lane, Dayton, OH 45409-1310
Ph 937-224-0661 Fax 937-224-5777 www.heapy.com

DAYTON CONVENTION CENTER
NEUTRAL ANALYSIS

OWNER
DAYTON CONVENTION &
VISITORS BUREAU
1 CHAMBER PLAZA, SUITE A
DAYTON, OHIO 45402

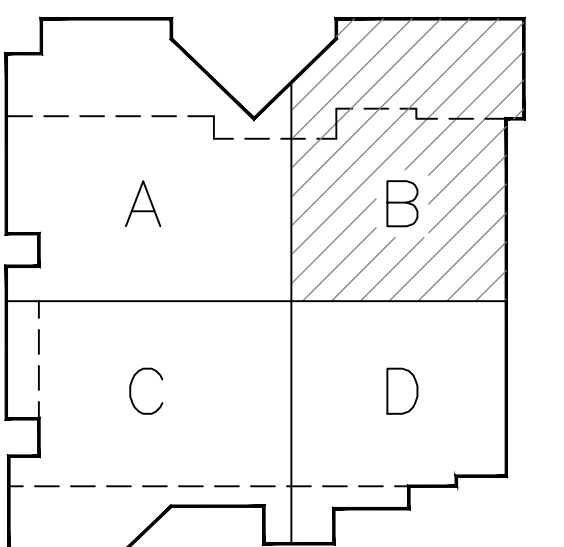


KEY PLAN
SCALE: NONE

PROJECT NO:	2017-07081
CAD DWG FILE:	E2.2 SECOND FLOOR PLAN - AREA B.DWG
DRAWN BY:	-
CHK'D BY:	-
COPYRIGHT:	-

SHEET TITLE
SECOND FLOOR PLAN - AREA B

SHEET **E2.2**

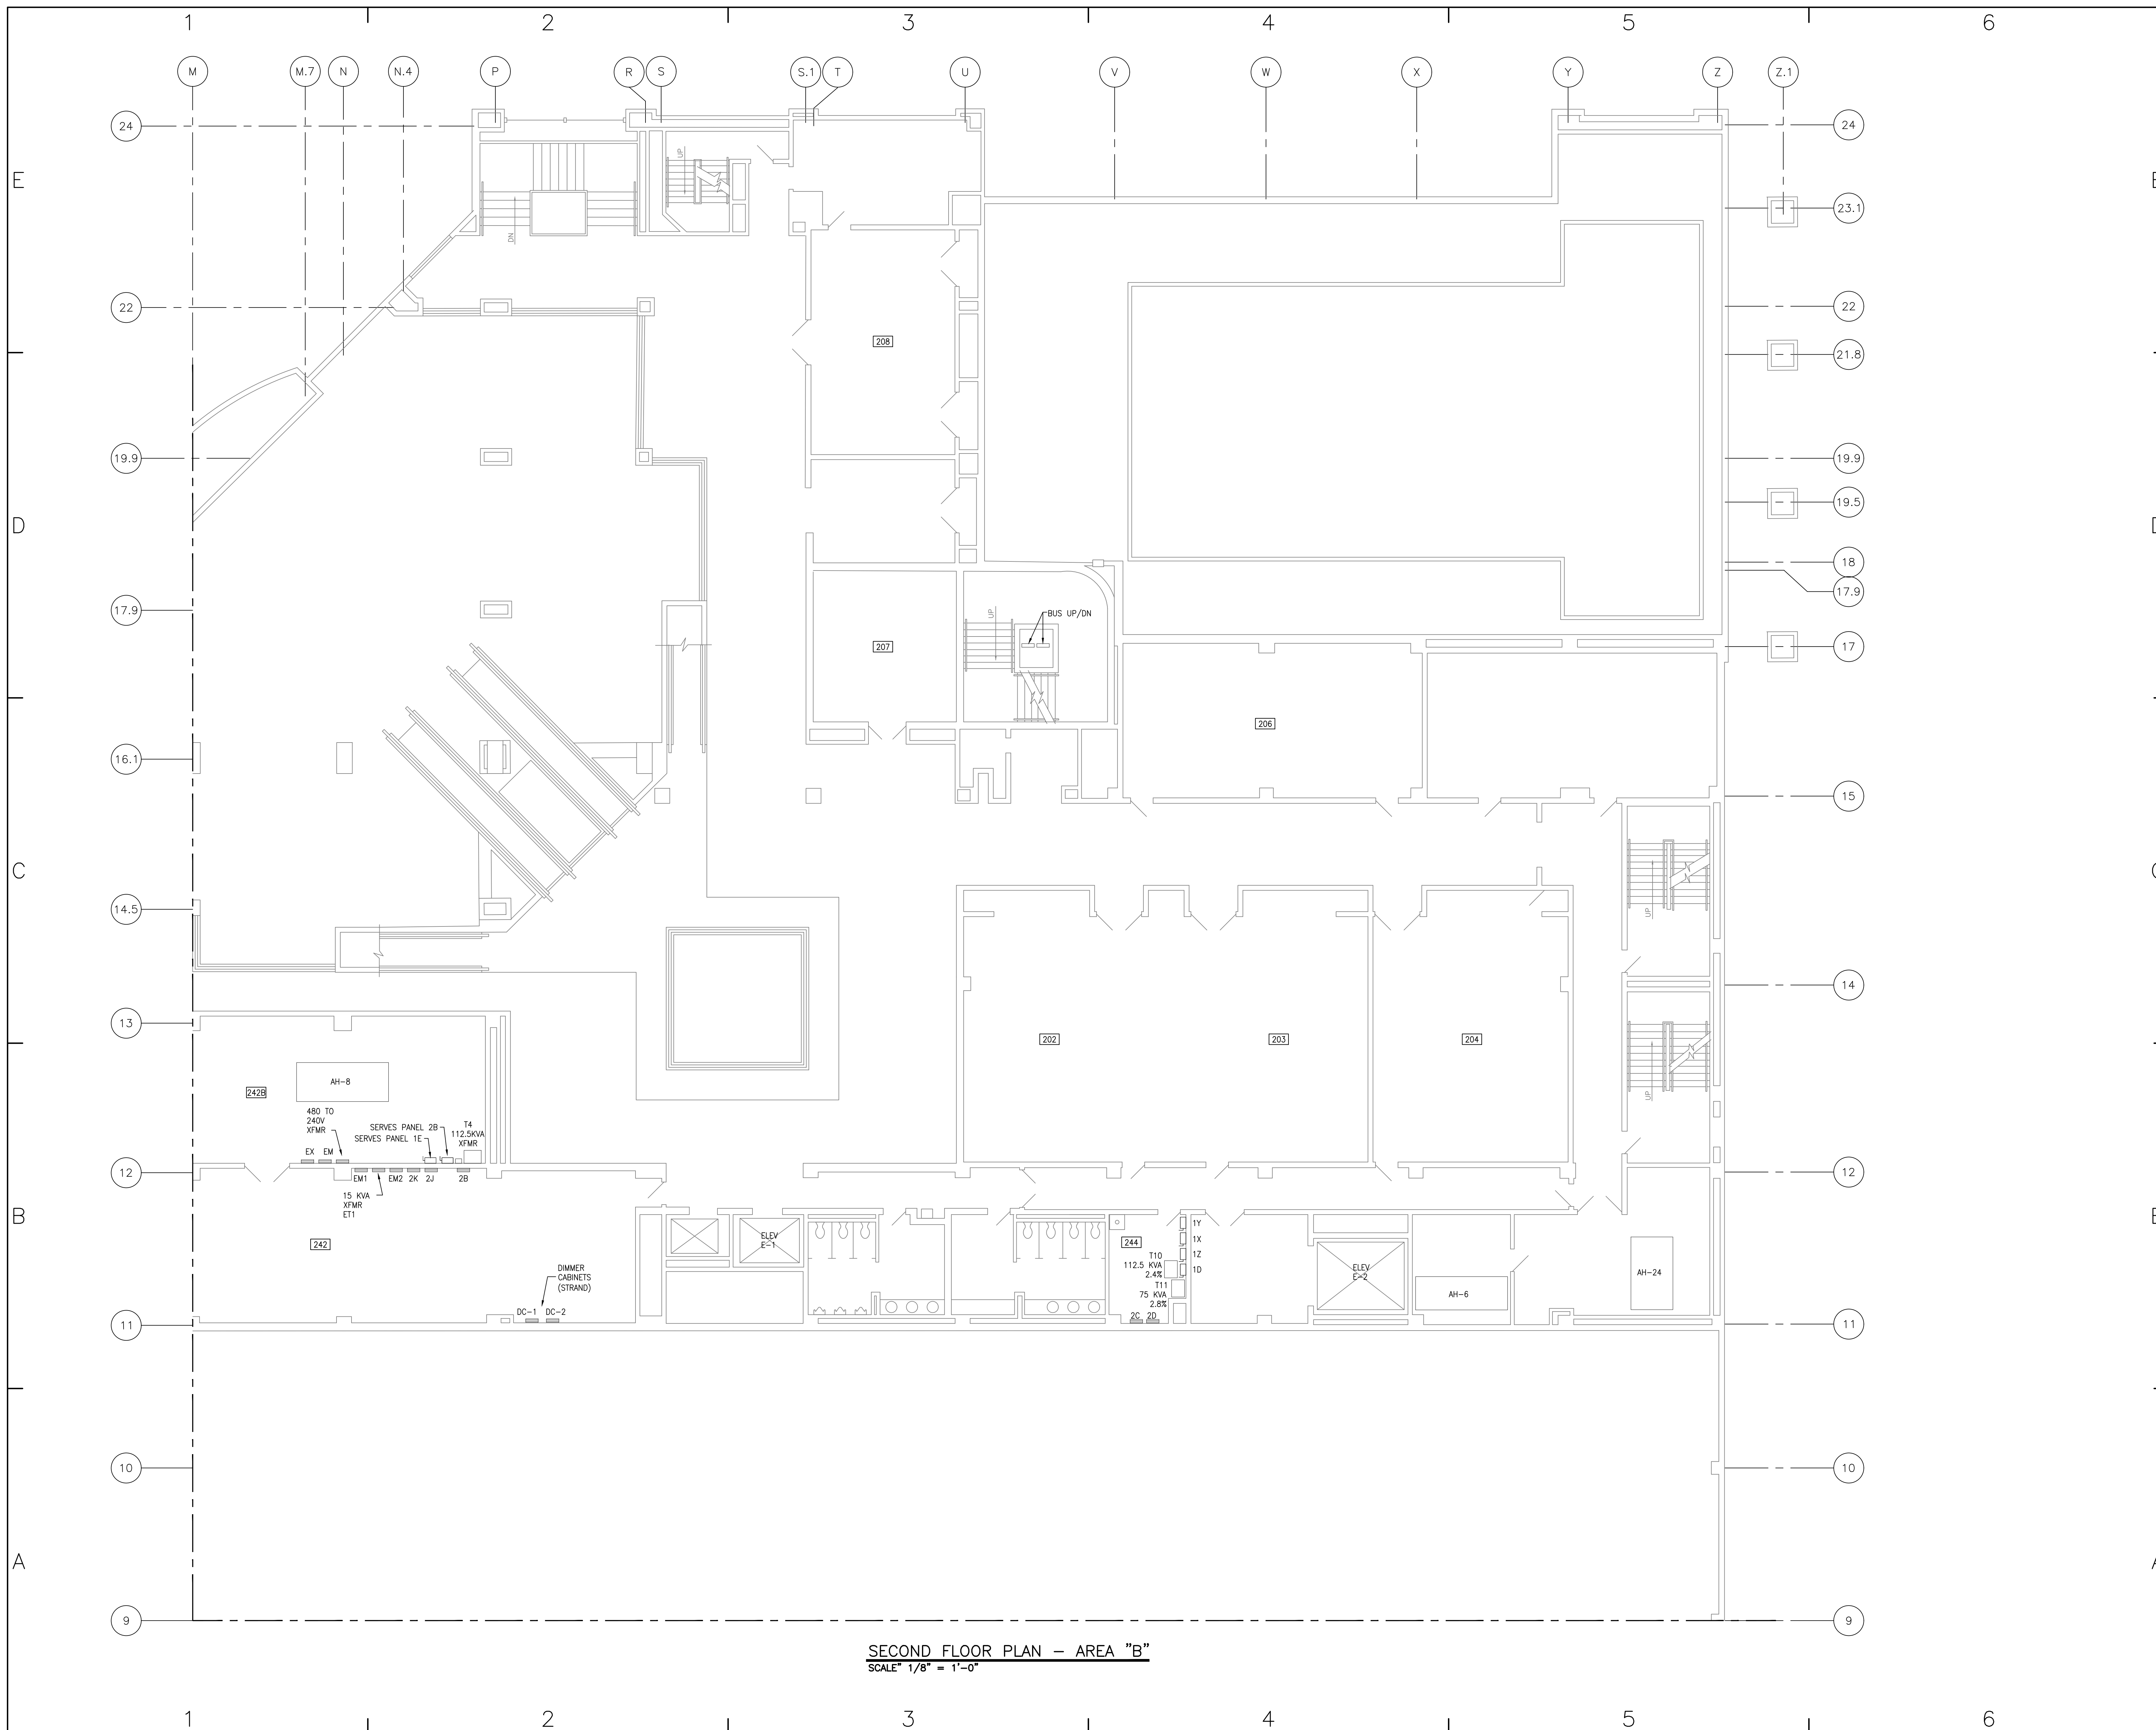


SECOND FLOOR PLAN - AREA "B"
SCALE: 1/8" = 1'-0"

PROJECT NO. 2017-07081
HEAPY ENGINEERING
DAYTON/COLUMBUS, OHIO & INDIANAPOLIS, INDIANA
MECHANICAL ELECTRICAL COMMISSIONING TECHNOLOGY

DESIGNED BY: [Name]
PLOT/REF DATE: December 20, 2017

Not For Construction

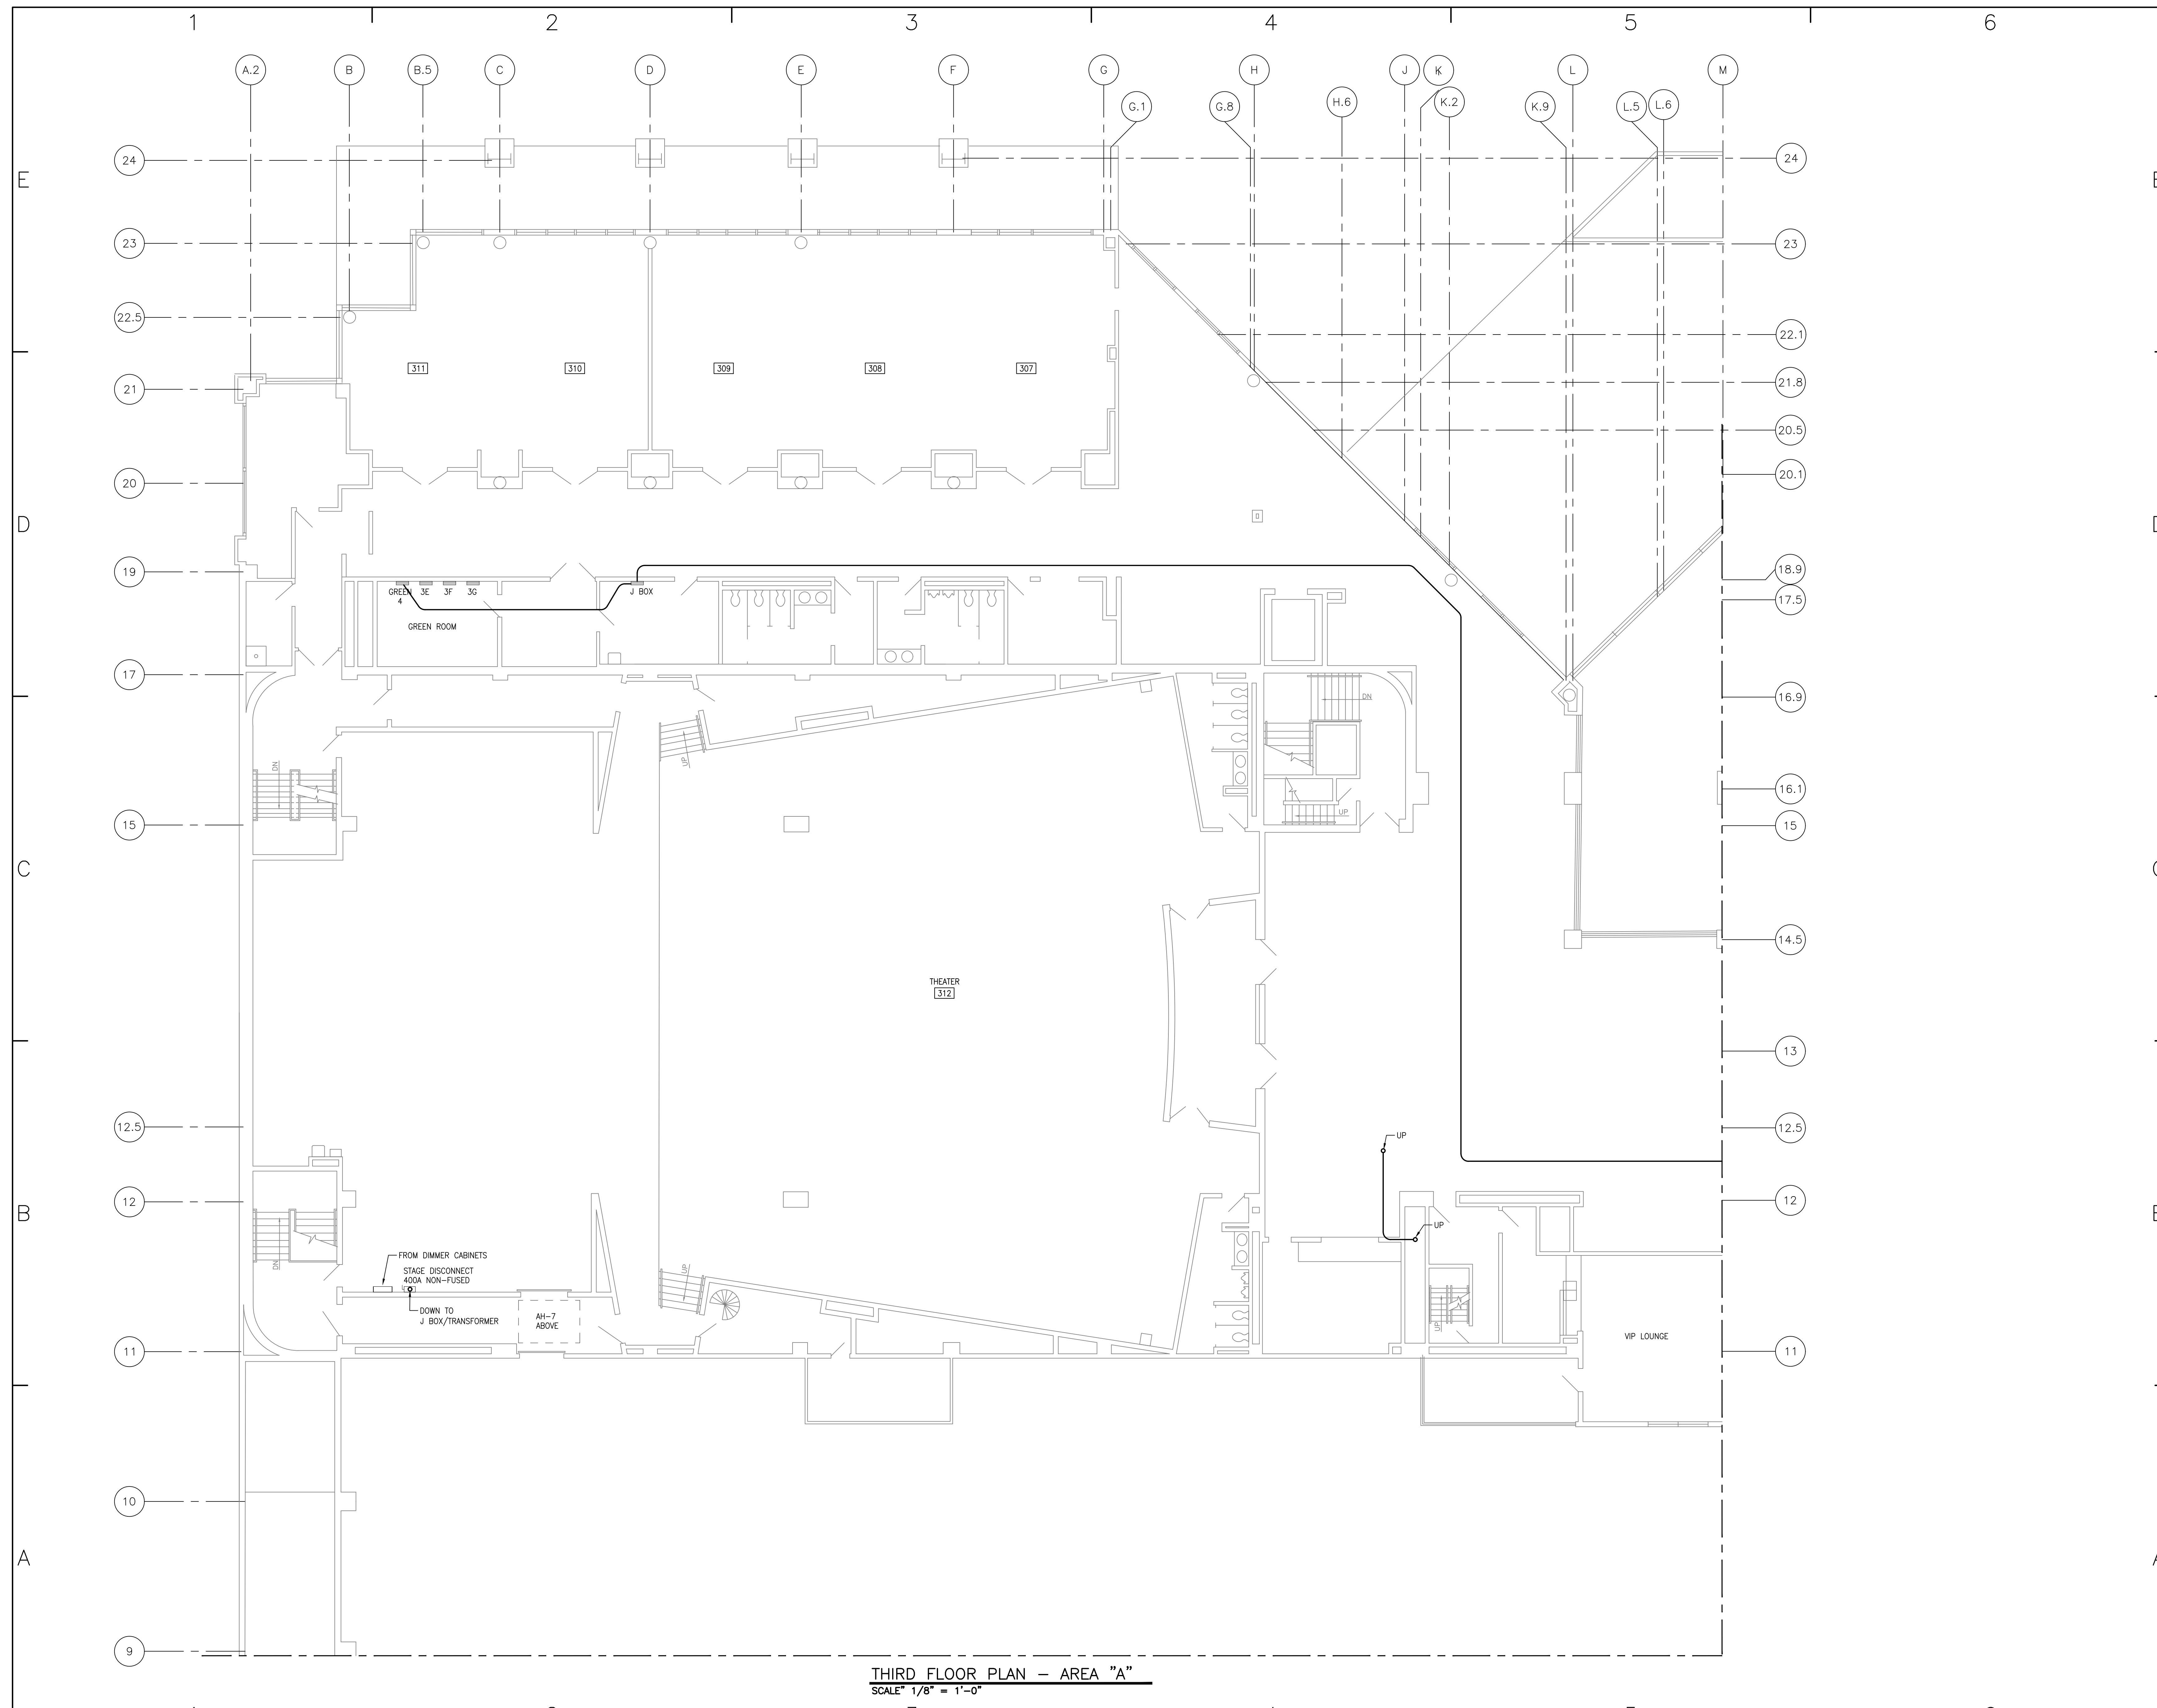


CONSULTANTS

Heapy Engineering
MEP Design Technology Planning Commissioning Energy
Nationally Recognized Leader in Sustainability

1400 W Dorothy Lane, Dayton, OH 45409-1310
Ph 937-224-0661 Fax 937-224-5777 www.heapy.com

DAYTON CONVENTION CENTER
NEUTRAL ANALYSIS

OWNER
DAYTON CONVENTION & VISITORS BUREAU
1 CHAMBER PLAZA, SUITE A
DAYTON, OHIO 45402

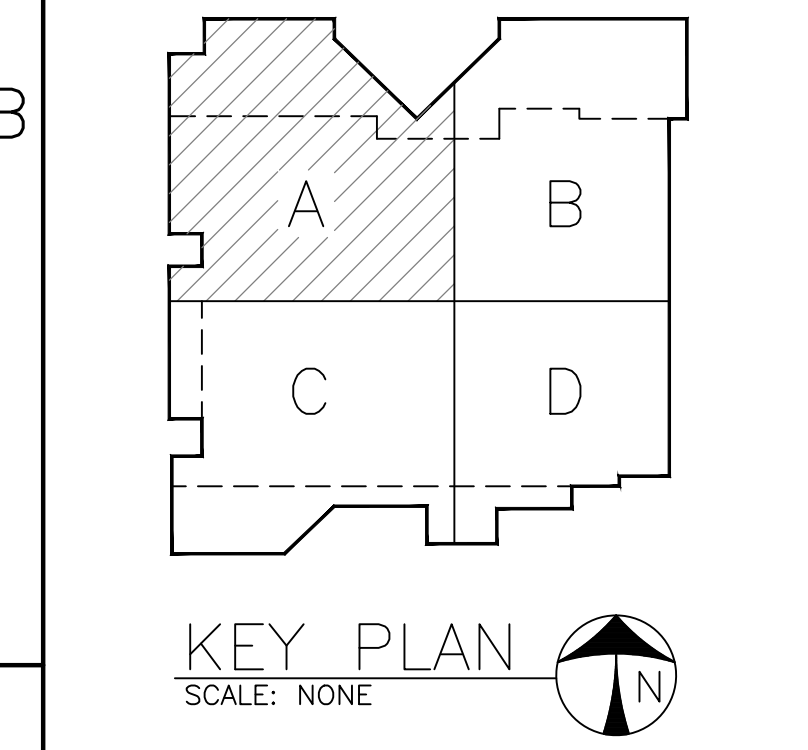

MARK	DATE	DESCRIPTION
12/21/17	12/21/17	DOCUMENT SET
PROJECT NO:	2017-07081	
CAD DWG FILE:	E3.1 THIRD FLOOR PLAN - AREA A.DWG	
DRAWN BY:	-	
CHK'D BY:	-	
COPYRIGHT:		
SHEET TITLE		
THIRD FLOOR PLAN - AREA A		

THIRD FLOOR PLAN - AREA "A"
SCALE 1/8" = 1'-0"

Not For Construction


CONSULTANTS

Heapy Engineering
MEP Design Technology Planning Commissioning Energy
Nationally Recognized Leader in Sustainability
1400 W Dorothy Lane, Dayton, OH 45409-1310
Ph 937-224-0661 Fax 937-224-5777 www.heapy.com


DAYTON CONVENTION CENTER
NEUTRAL ANALYSIS

OWNER

DAYTON CONVENTION &
VISITORS BUREAU
1 CHAMBER PLAZA, SUITE A
DAYTON, OHIO 45402

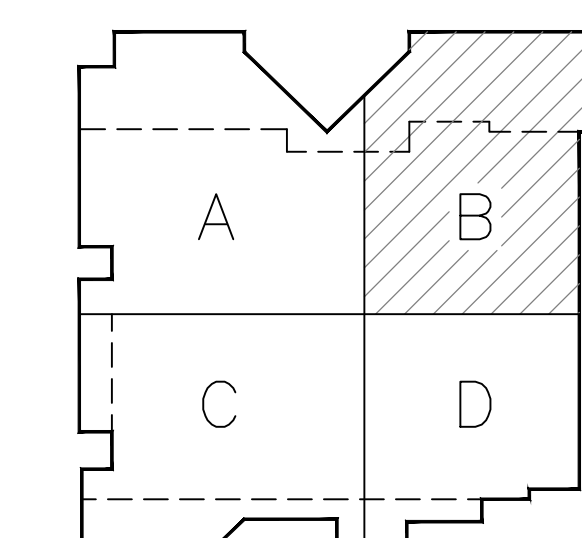

KEY PLAN
SCALE: NONE

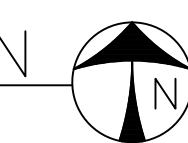

12/21/17 DOCUMENT SET

MARK DATE DESCRIPTION

PROJECT NO: 2017-07081

CAD DWG FILE: E3.2 THIRD FLOOR PLAN - AREA B.DWG

DRAWN BY: -

CHK'D BY: -

COPYRIGHT:


SHEET TITLE

THIRD FLOOR PLAN - AREA B

E3.2

SHEET

THIRD FLOOR PLAN - AREA "B"
SCALE 1/8" = 1'-0"

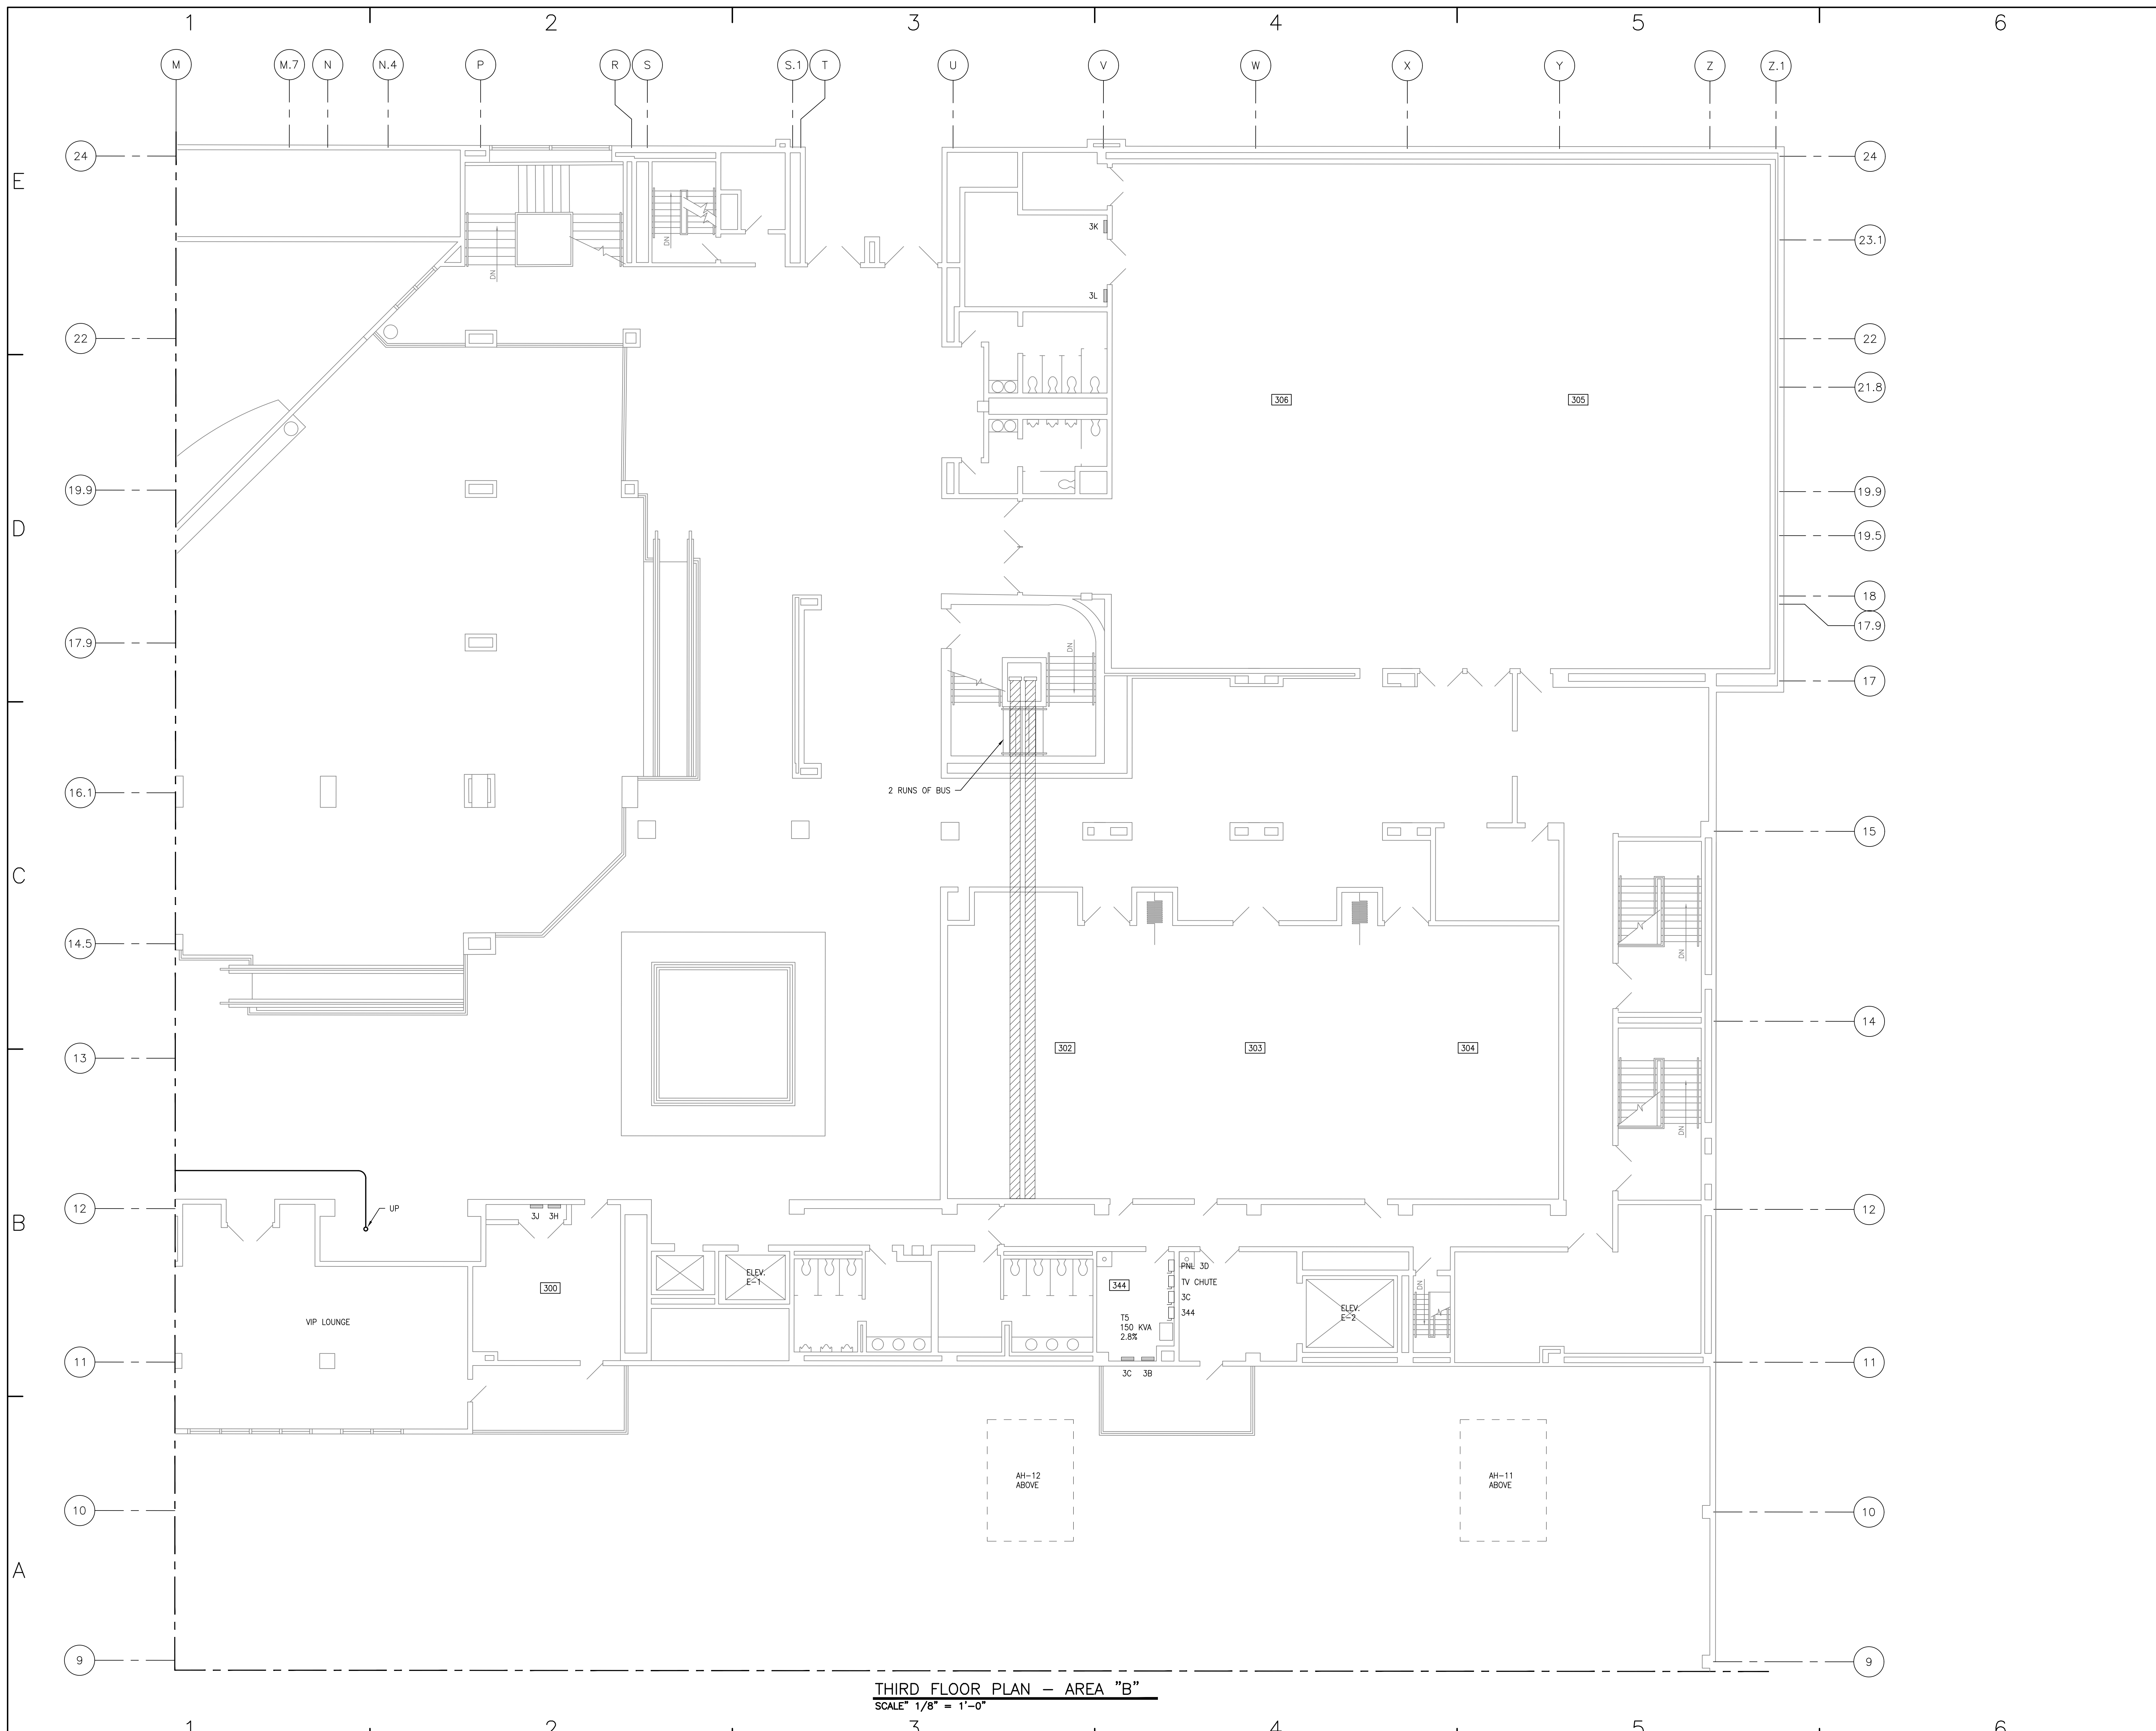

PROJECT NO: 2017-07081
DRAWN BY: -
CHECKED BY: -
DATE: December 20, 2017
DAYTON/COLUMBUS, OHIO & INDIANAPOLIS, INDIANA
MECHANICAL ELECTRICAL COMMISSIONING TECHNOLOGY



Not For Construction


- NOTES**
- 1 FUSED DISCONNECT.
 - 2 NON-FUSED DISCONNECT.
 - 3 TRANSFORMER.

CONSULTANTS

Heapy Engineering
MEP Design Technology Planning Commissioning Energy
Nationally Recognized Leader in Sustainability
1400 W Dorothy Lane, Dayton, OH 45409-1310
Ph 937-224-0661 Fax 937-224-5777 www.heapy.com

**DAYTON CONVENTION CENTER
NEUTRAL ANALYSIS**

OWNER
DAYTON CONVENTION &
VISITORS BUREAU
1 CHAMBER PLAZA, SUITE A
DAYTON, OHIO 45402

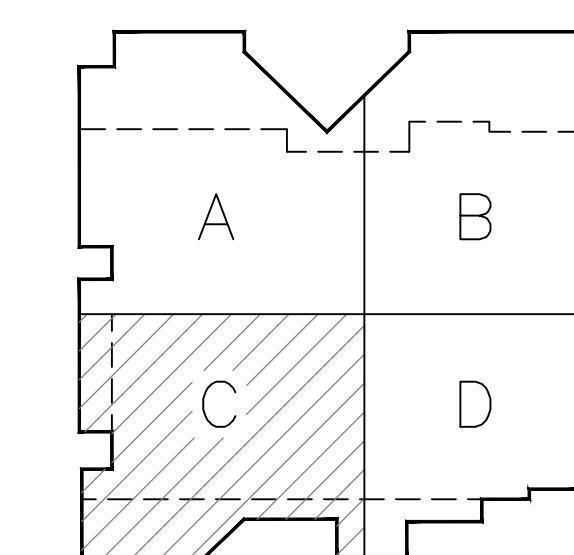


KEY PLAN
SCALE: NONE

PROJECT NO:	2017-07081
CAD DWG FILE:	E3.3 THIRD FLOOR PLAN - AREA C.DWG
DRAWN BY:	-
CHK'D BY:	-
COPYRIGHT:	-

SHEET TITLE
THIRD FLOOR PLAN - AREA C

SHEET
E3.3

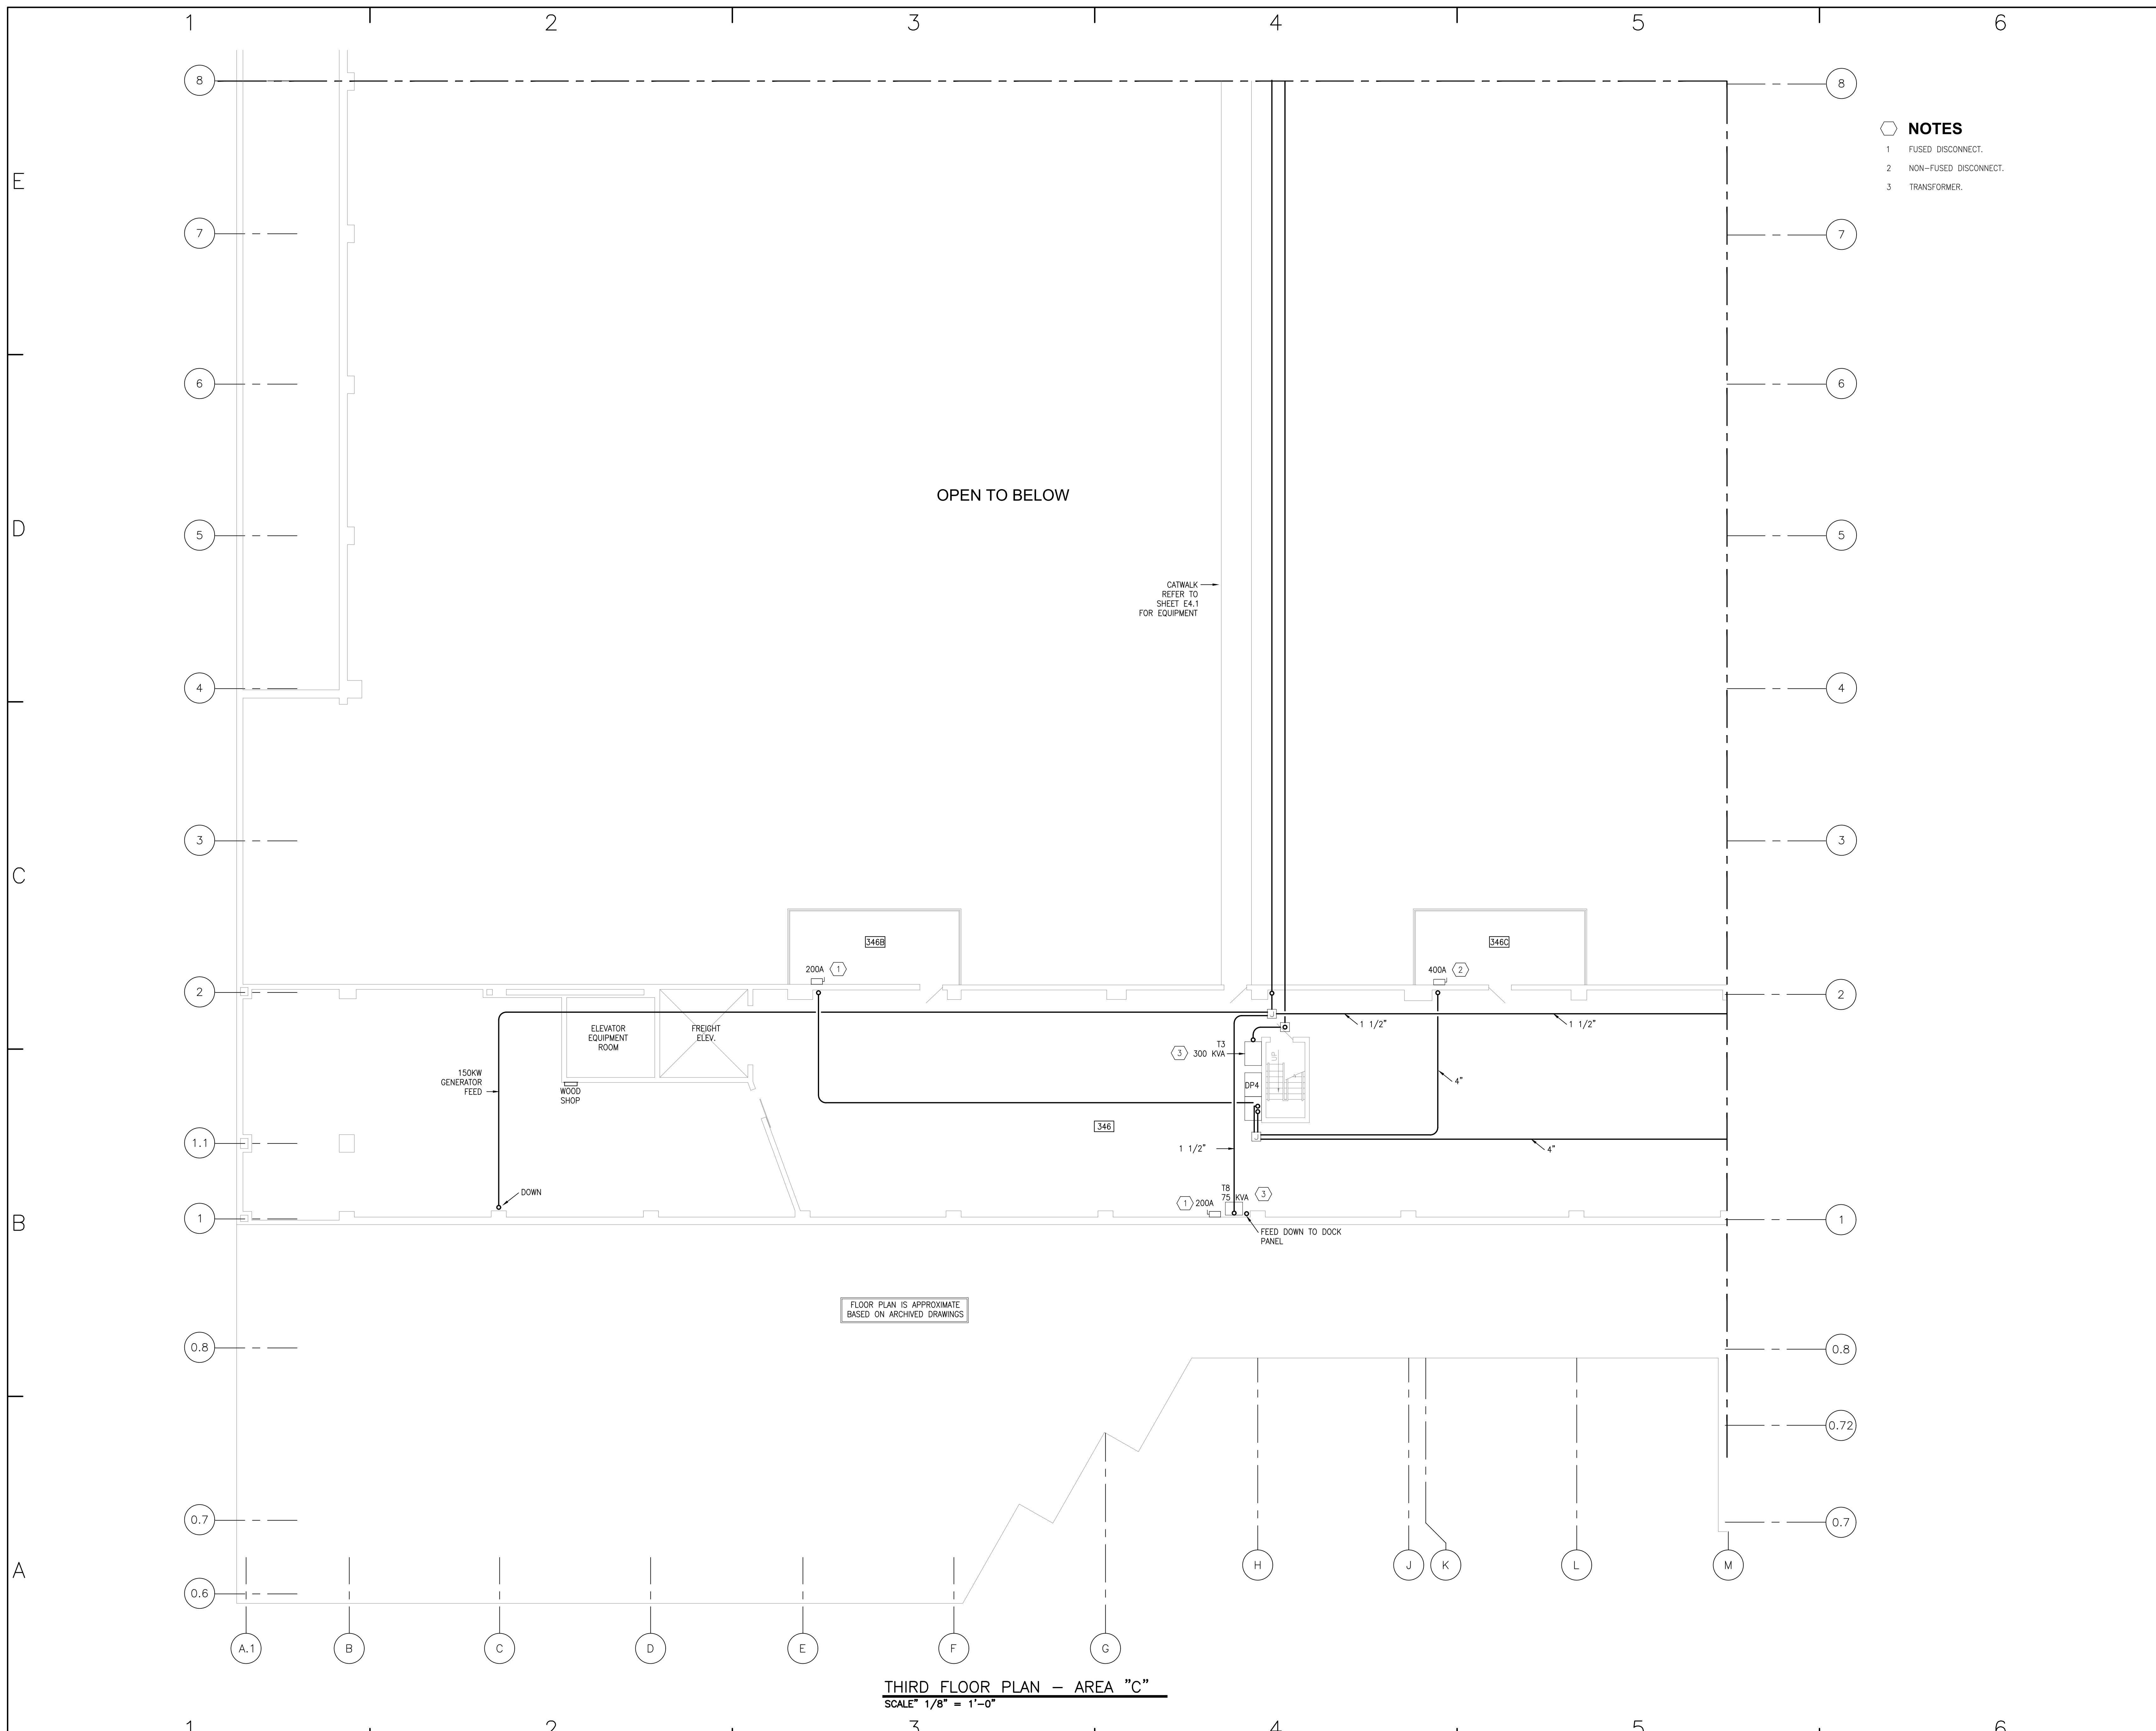


THIRD FLOOR PLAN - AREA "C"
SCALE 1/8" = 1'-0"

PROJECT NO. 2017-07081
HEAPY ENGINEERING
DAYTON/COLUMBUS, OHIO & INDIANAPOLIS, INDIANA
MECHANICAL ELECTRICAL COMMISSIONING TECHNOLOGY

Not For Construction

- NOTES**
- 1 FUSED DISCONNECT.
 - 2 NON-FUSED DISCONNECT.
 - 3 TRANSFORMER.

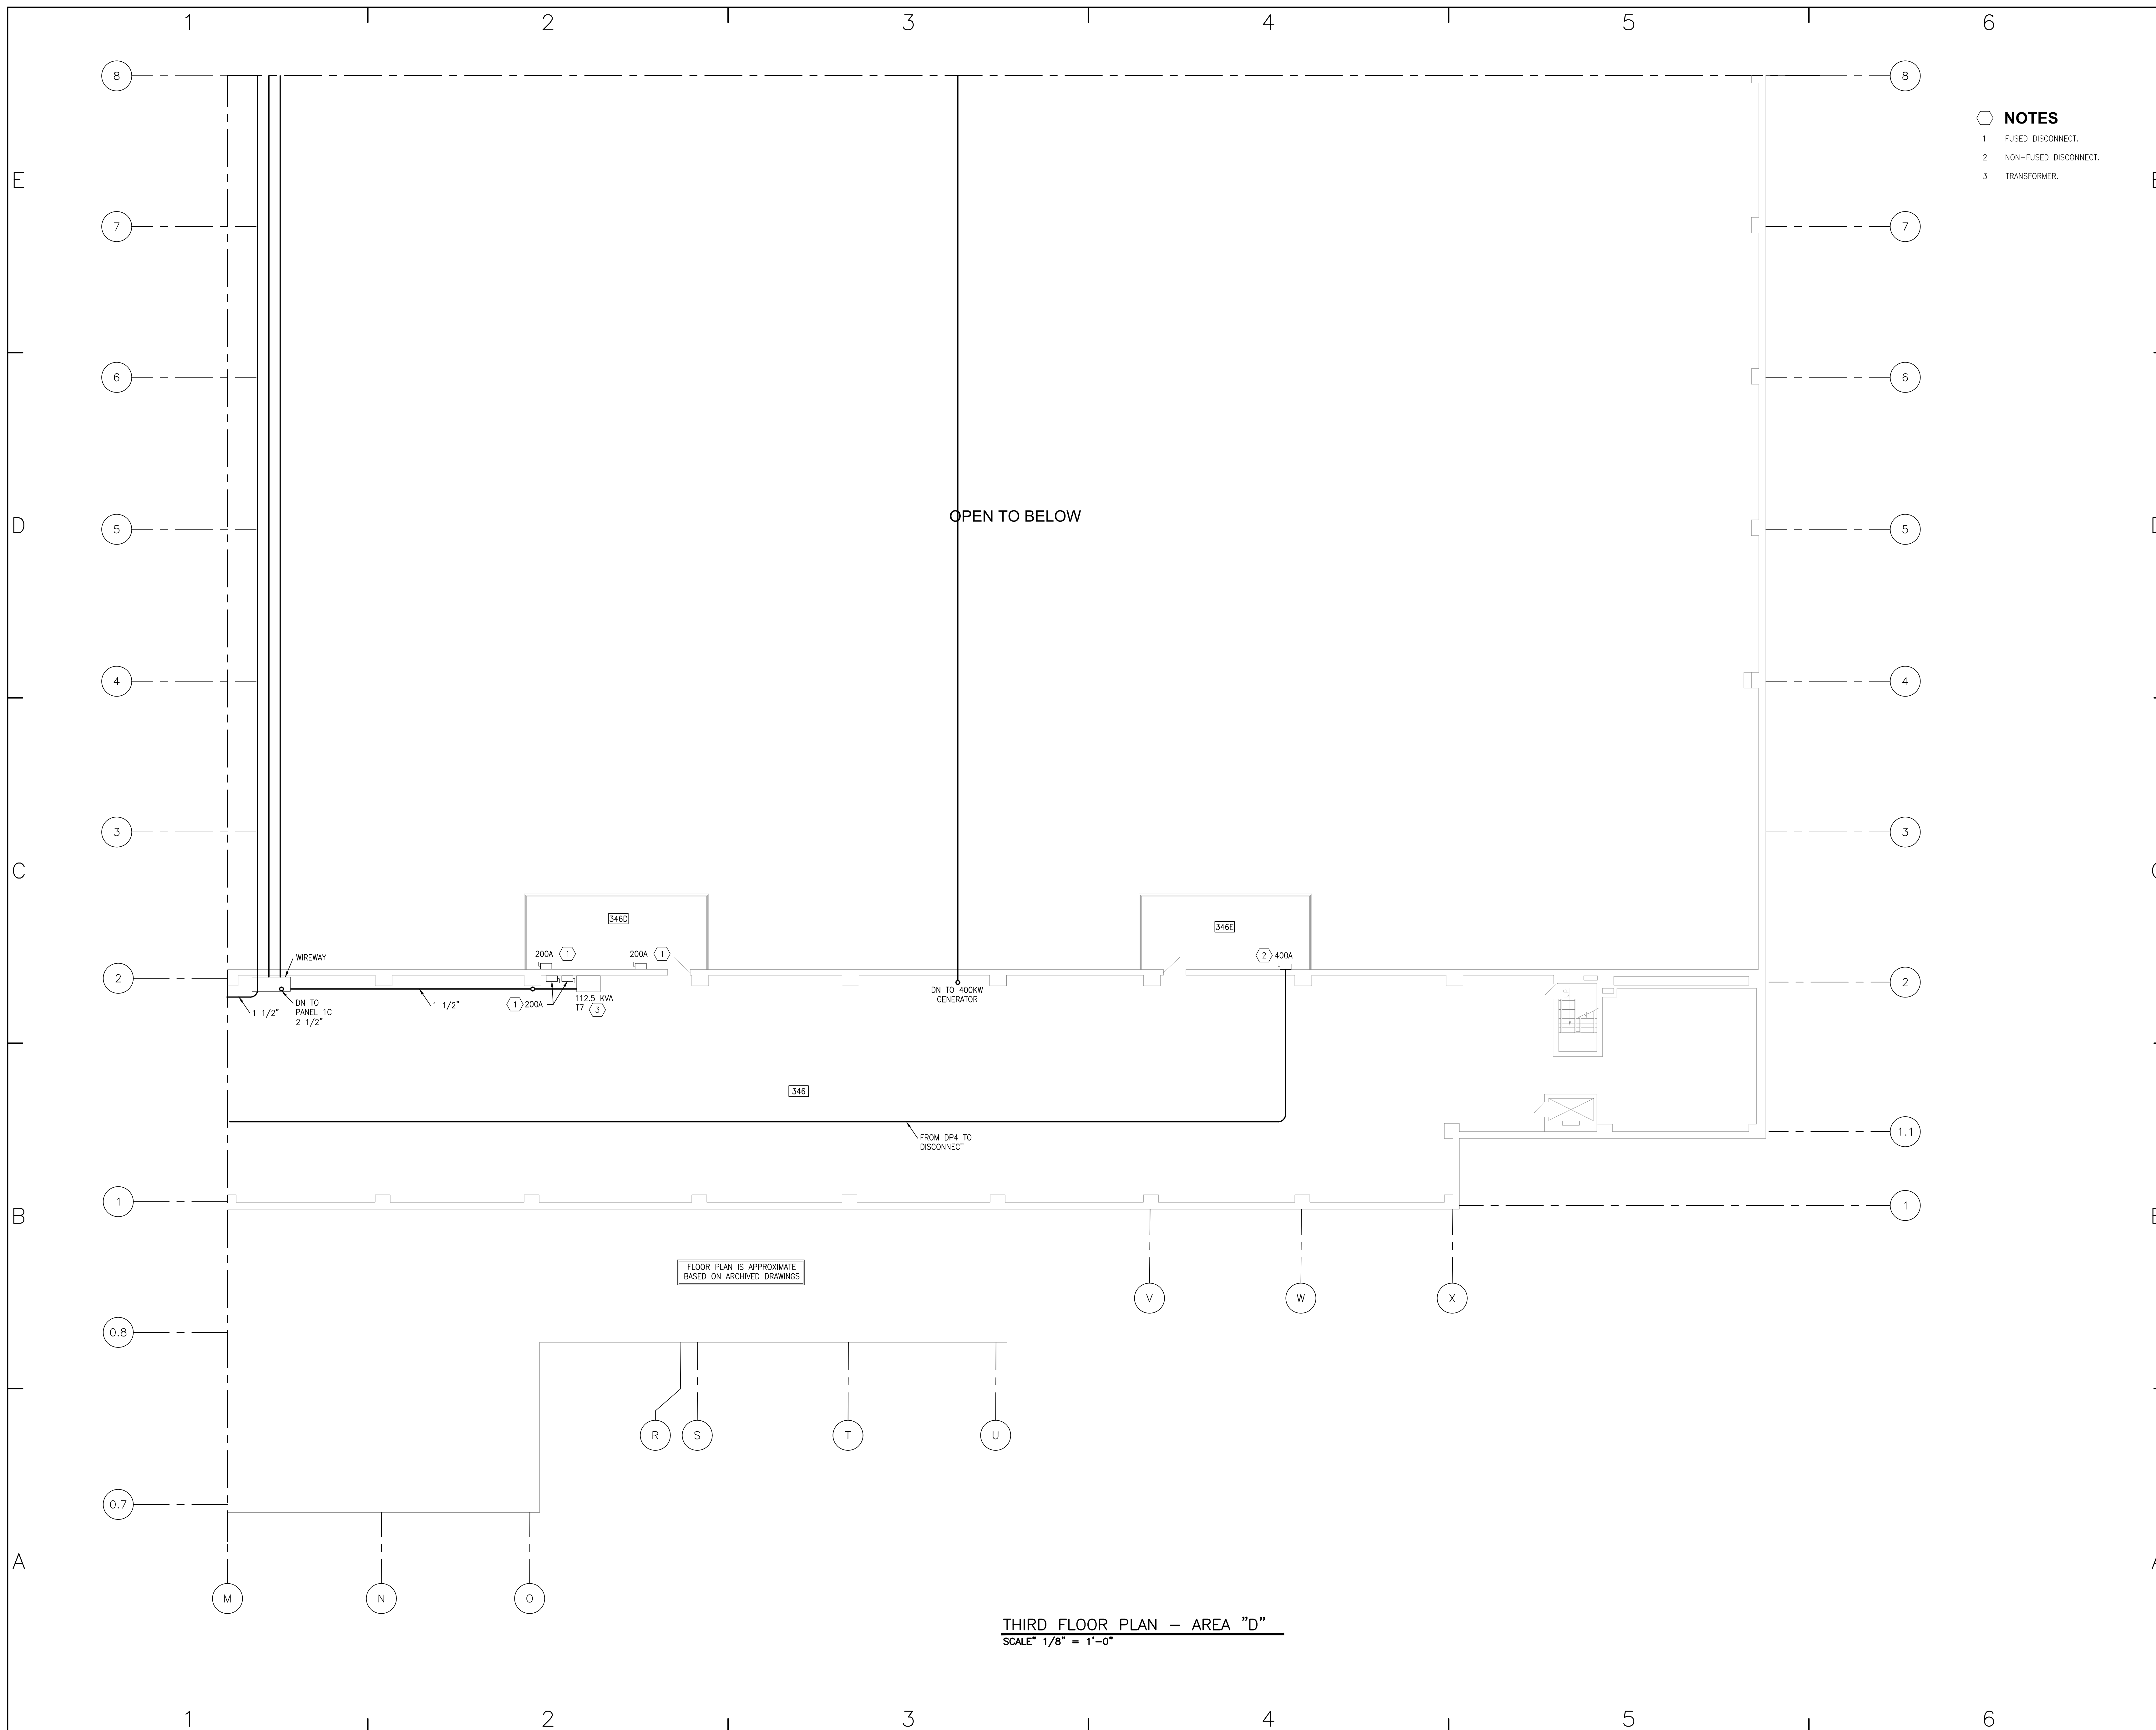


CONSULTANTS

Heapy Engineering
 MEP Design Technology Planning Commissioning Energy
 1400 W Dorothy Lane, Dayton, OH 45409-1310
 Ph 937-224-0861 Fax 937-224-5777 www.heapy.com

DAYTON CONVENTION CENTER
 NEUTRAL ANALYSIS

OWNER
 DAYTON CONVENTION &
 VISITORS BUREAU
 1 CHAMBER PLAZA, SUITE A
 DAYTON, OHIO 45402

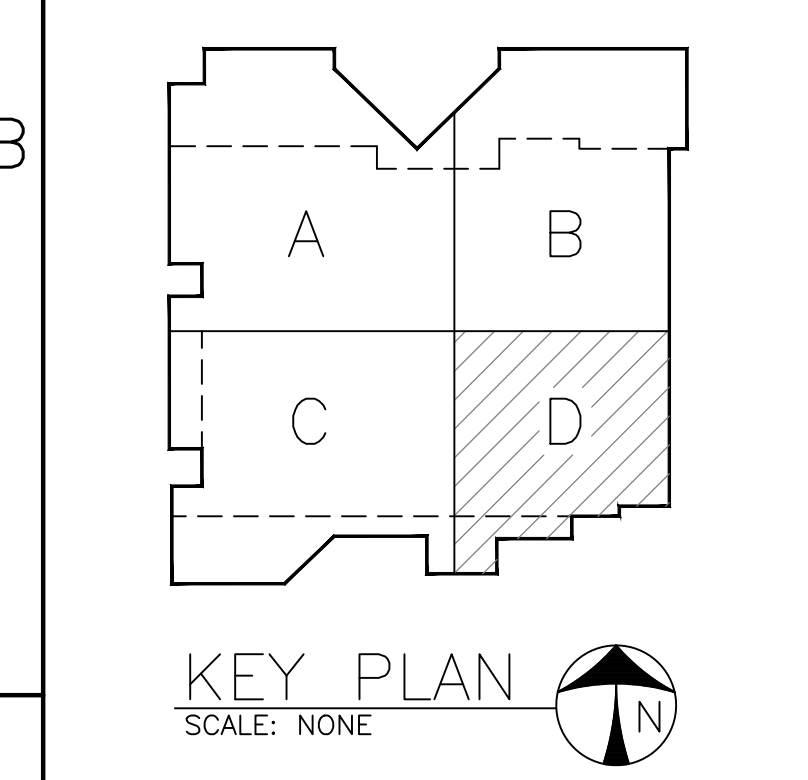

PROJECT NO:	2017-07081
CAD DWG FILE:	E3.4 THIRD FLOOR PLAN - AREA D.DWG
DRAWN BY:	-
CHK'D BY:	-
COPYRIGHT:	-
SHEET TITLE:	THIRD FLOOR PLAN - AREA D
SHEET:	E3.4

THIRD FLOOR PLAN - AREA "D"
 SCALE 1/8" = 1'-0"


PROJECT NO: 2017-07081
 HEAPY ENGINEERING
 DAYTON/COLUMBUS, OHIO & INDIANAPOLIS, INDIANA
 MECHANICAL ELECTRICAL COMMISSIONING TECHNOLOGY



Not For Construction

CONSULTANTS
Heapy Engineering
 MEP Design Technology Planning Commissioning Energy
Nationally Recognized Leader in Sustainability
 1400 W Dorothy Lane, Dayton, OH 45409-1310
 Ph 937-224-0661 Fax 937-224-5777 www.heapy.com


DAYTON CONVENTION CENTER
 NEUTRAL ANALYSIS
 OWNER
 DAYTON CONVENTION &
 VISITORS BUREAU
 1 CHAMBER PLAZA, SUITE A
 DAYTON, OHIO 45402

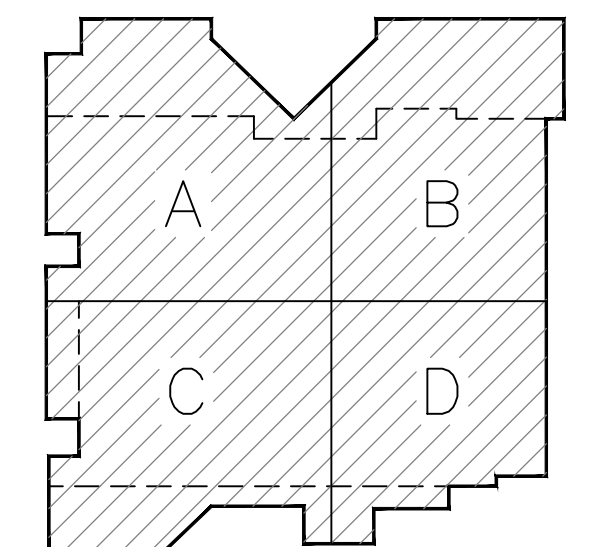

KEY PLAN
 SCALE: NONE

MARK	DATE	DESCRIPTION
12/21/17		DOCUMENT SET
PROJECT NO:	2017-07081	
CAD DWG FILE:	E4.1 FOURTH FLOOR PLAN.DWG	
DRAWN BY:	-	
CHK'D BY:	-	
COPYRIGHT:		

SHEET TITLE
FOURTH FLOOR PLAN
 E4.1
 SHEET

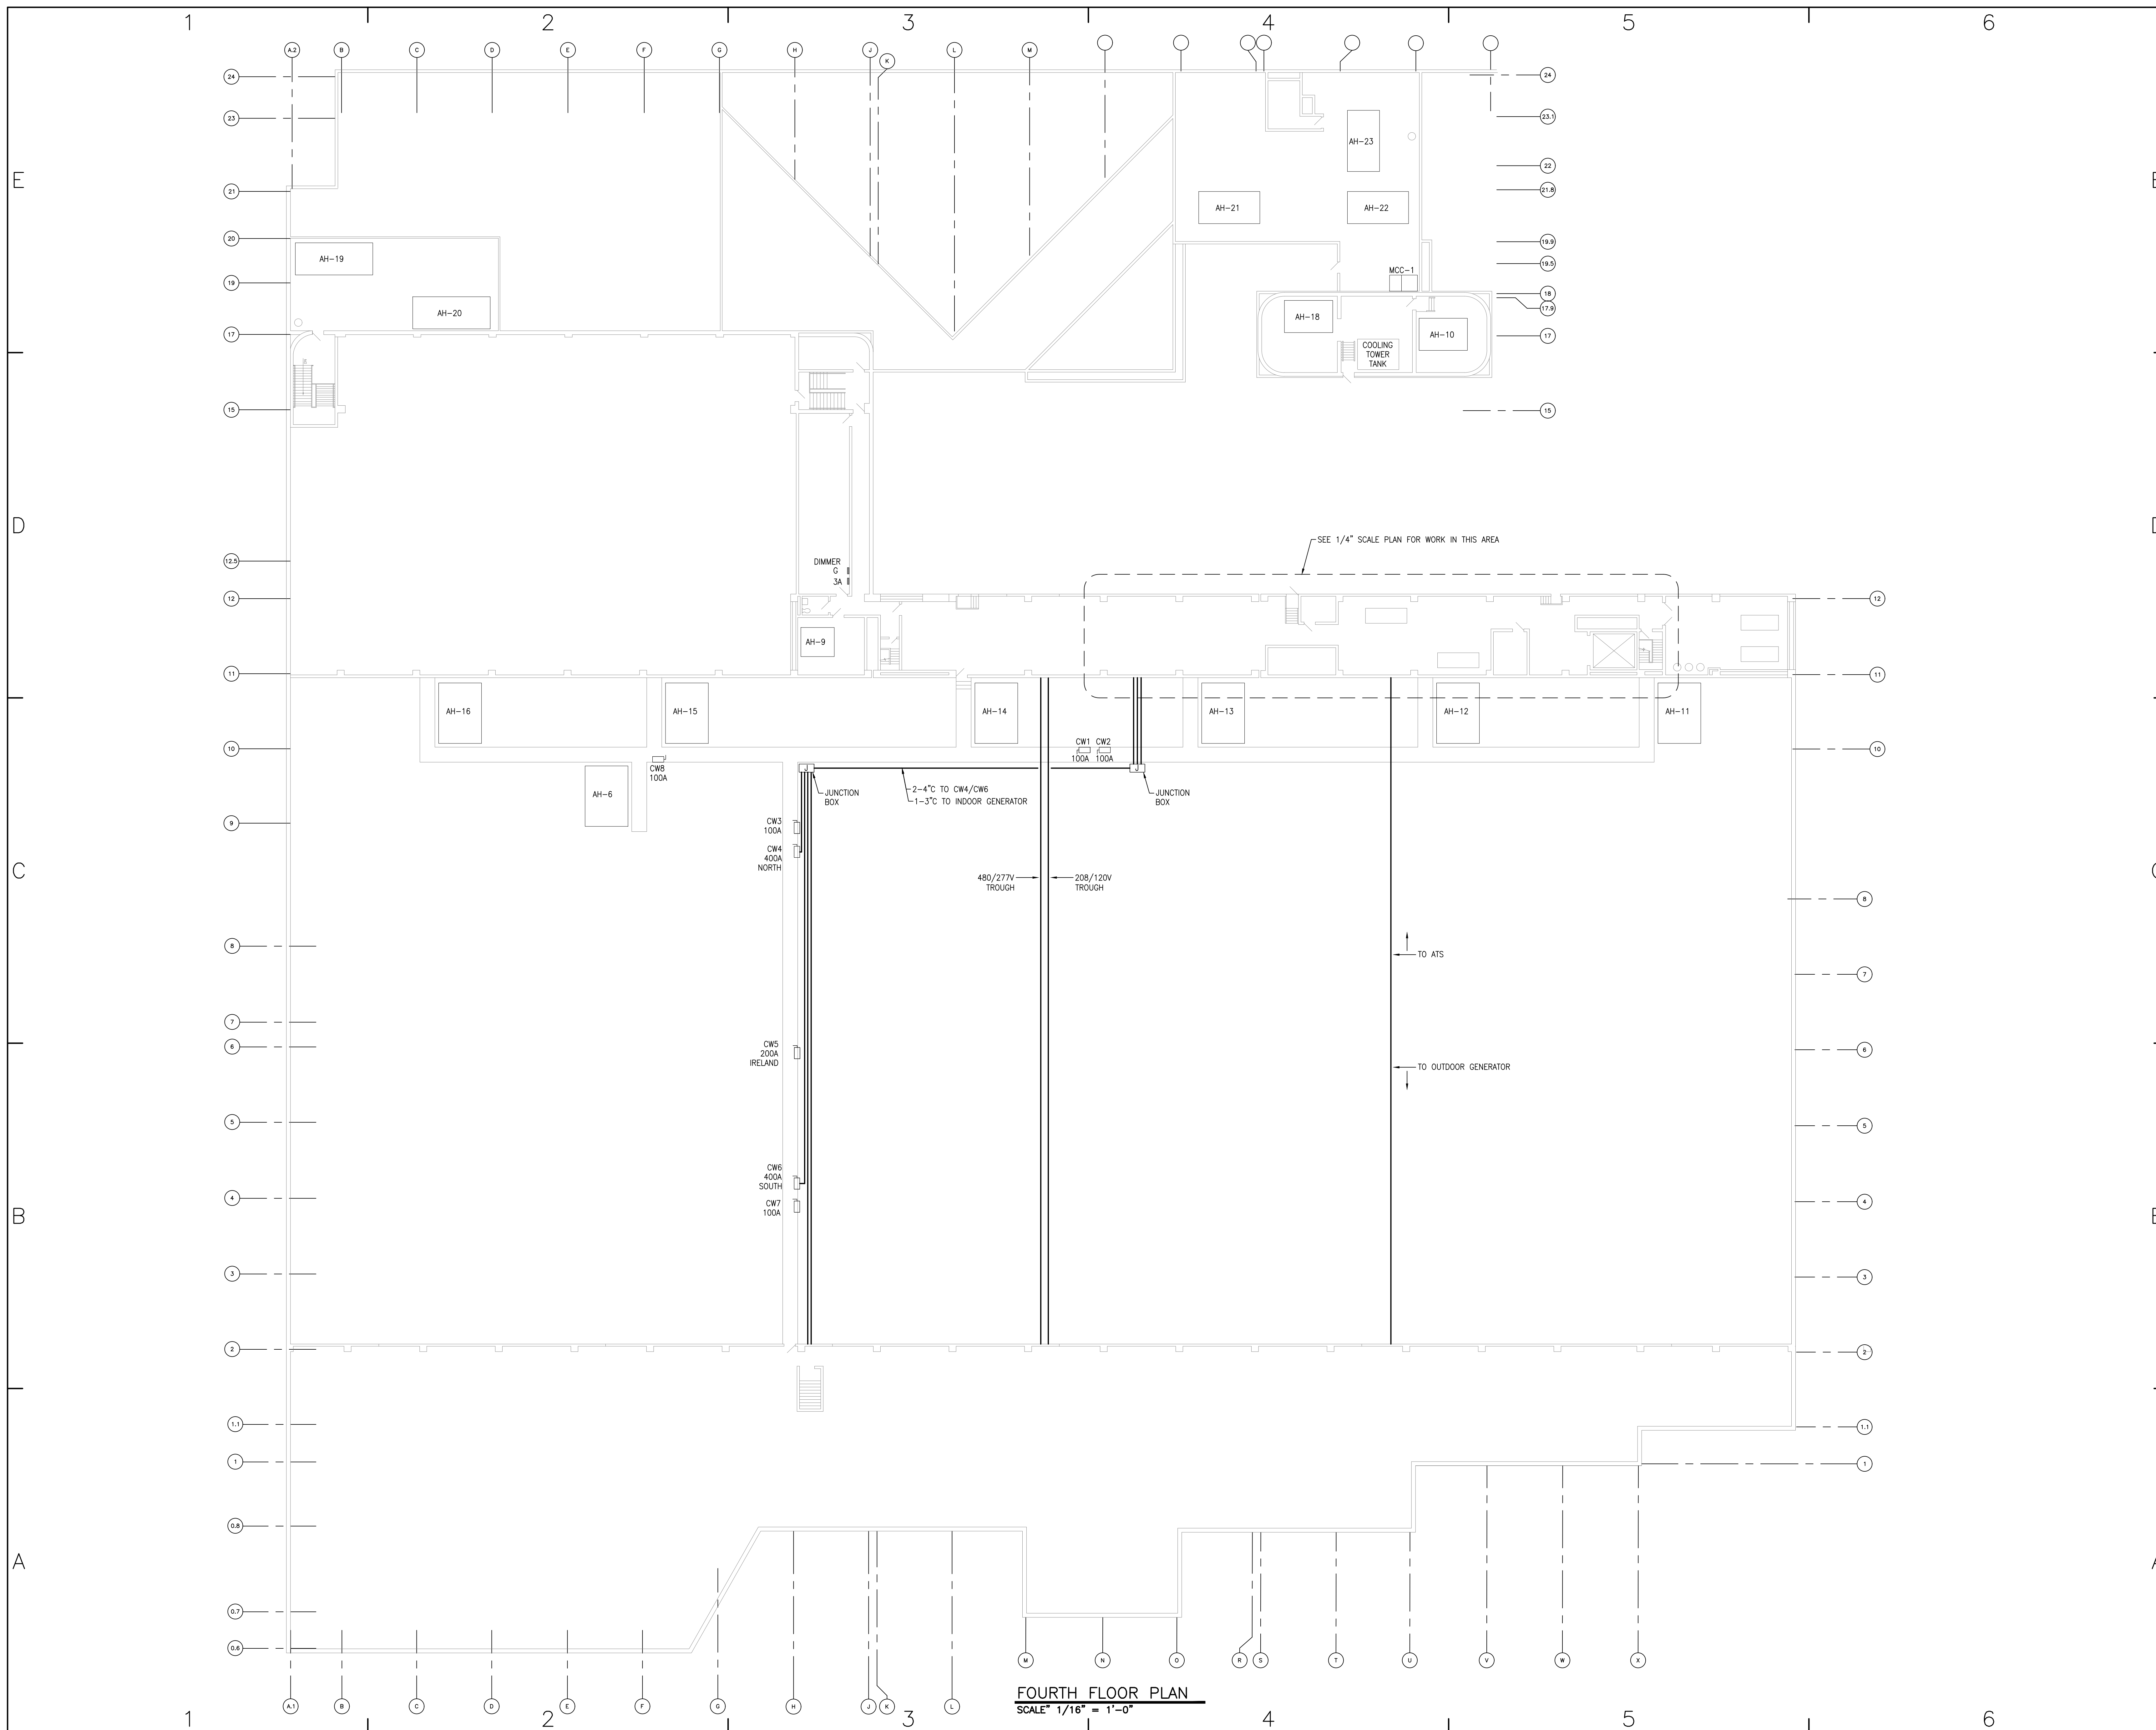

FOURTH FLOOR PLAN
 SCALE 1/16" = 1'-0"

PROJECT NO. 2017-07081
 HEAPY ENGINEERING
 DAYTON/COLUMBUS, OHIO & INDIANAPOLIS, INDIANA
 MECHANICAL ELECTRICAL COMMISSIONING TECHNOLOGY
 PLANNING DATE: December 20, 2017


Not For Construction

CONSULTANTS



Heapy Engineering
MEP Design Technology Planning Commissioning Energy
Nationally Recognized Leader in Sustainability
1400 W Dorothy Lane, Dayton, OH 45409-1310
Ph 937-224-0661 Fax 937-224-5777 www.heapy.com

DAYTON CONVENTION CENTER
NEUTRAL ANALYSIS

OWNER
DAYTON CONVENTION &
VISITORS BUREAU
1 CHAMBER PLAZA, SUITE A
DAYTON, OHIO 45402

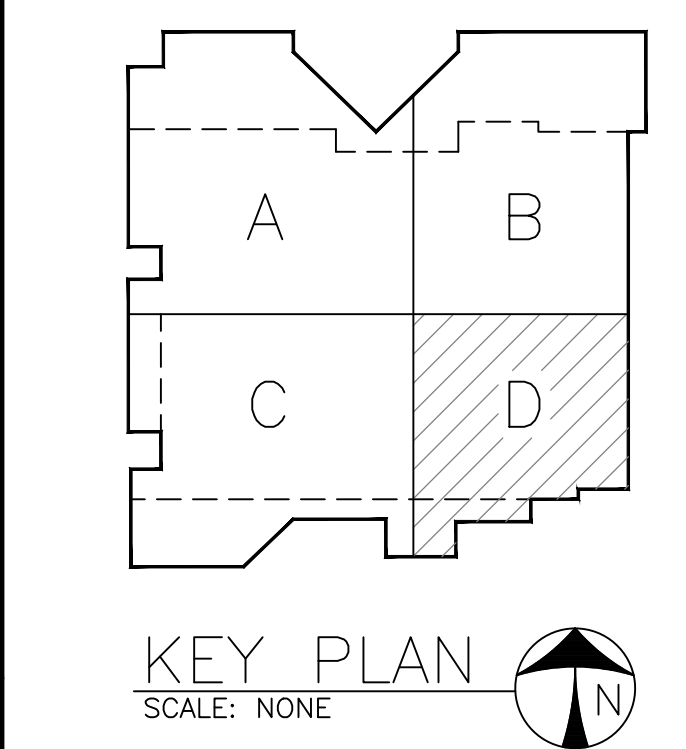


PROJECT NO:	2017-07081
CAD DWG FILE:	E4.1A PARTIAL FOURTH FLOOR PLAN.DWG
DRAWN BY:	-
CHK'D BY:	-
COPYRIGHT:	-
SHEET TITLE	PARTIAL FOURTH FLOOR PLAN
SHEET	E4.1A

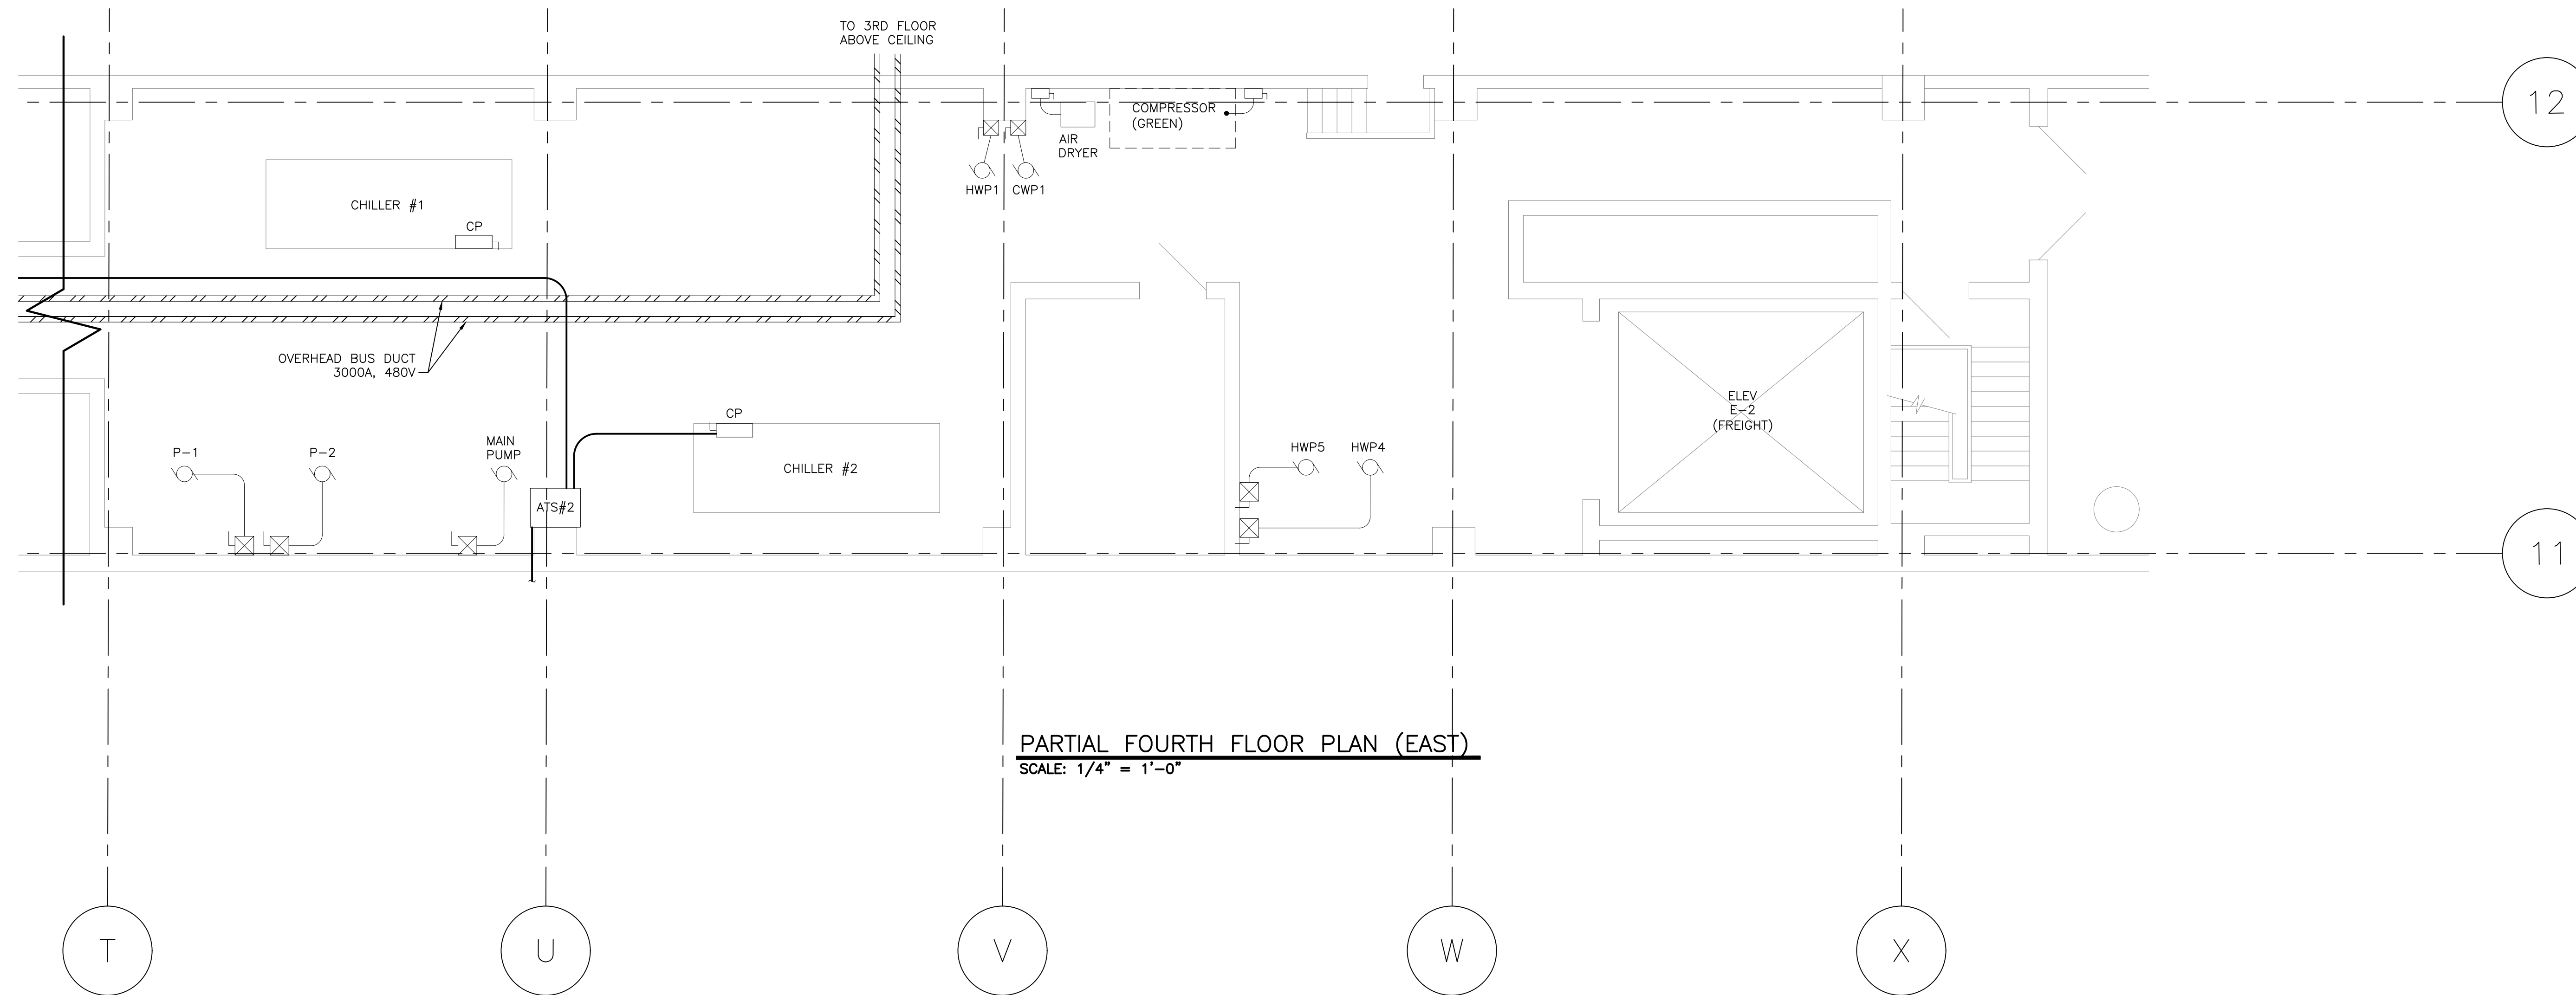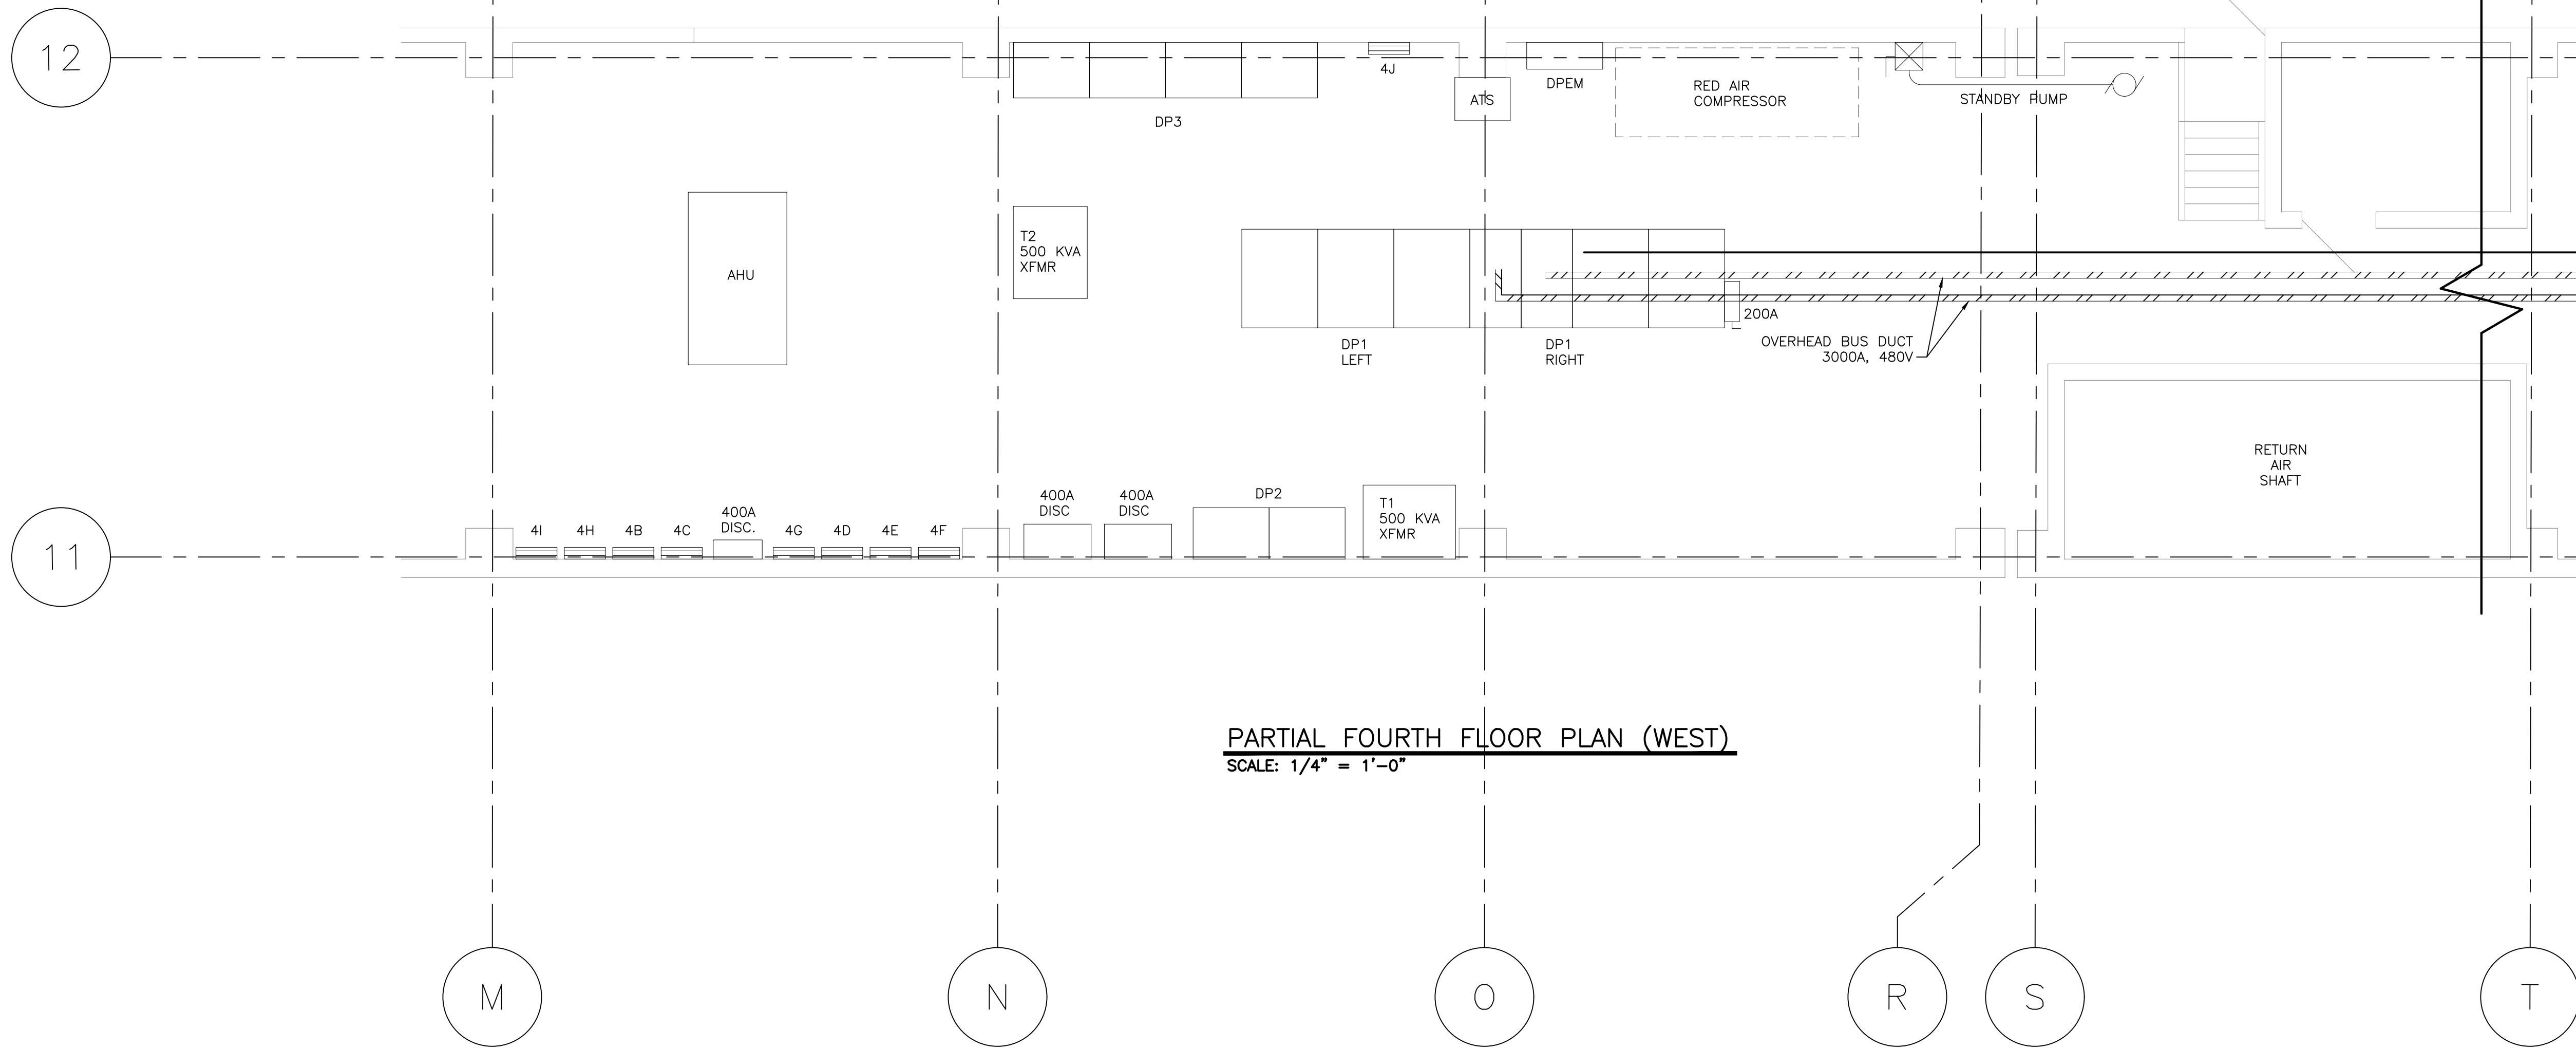

PROJECT NO. 2017-07081
HEAPY ENGINEERING
DAYTON/COLUMBUS, OHIO & INDIANAPOLIS, INDIANA
MECHANICAL ELECTRICAL COMMISSIONING TECHNOLOGY

DATE: December 20, 2017

Not For Construction

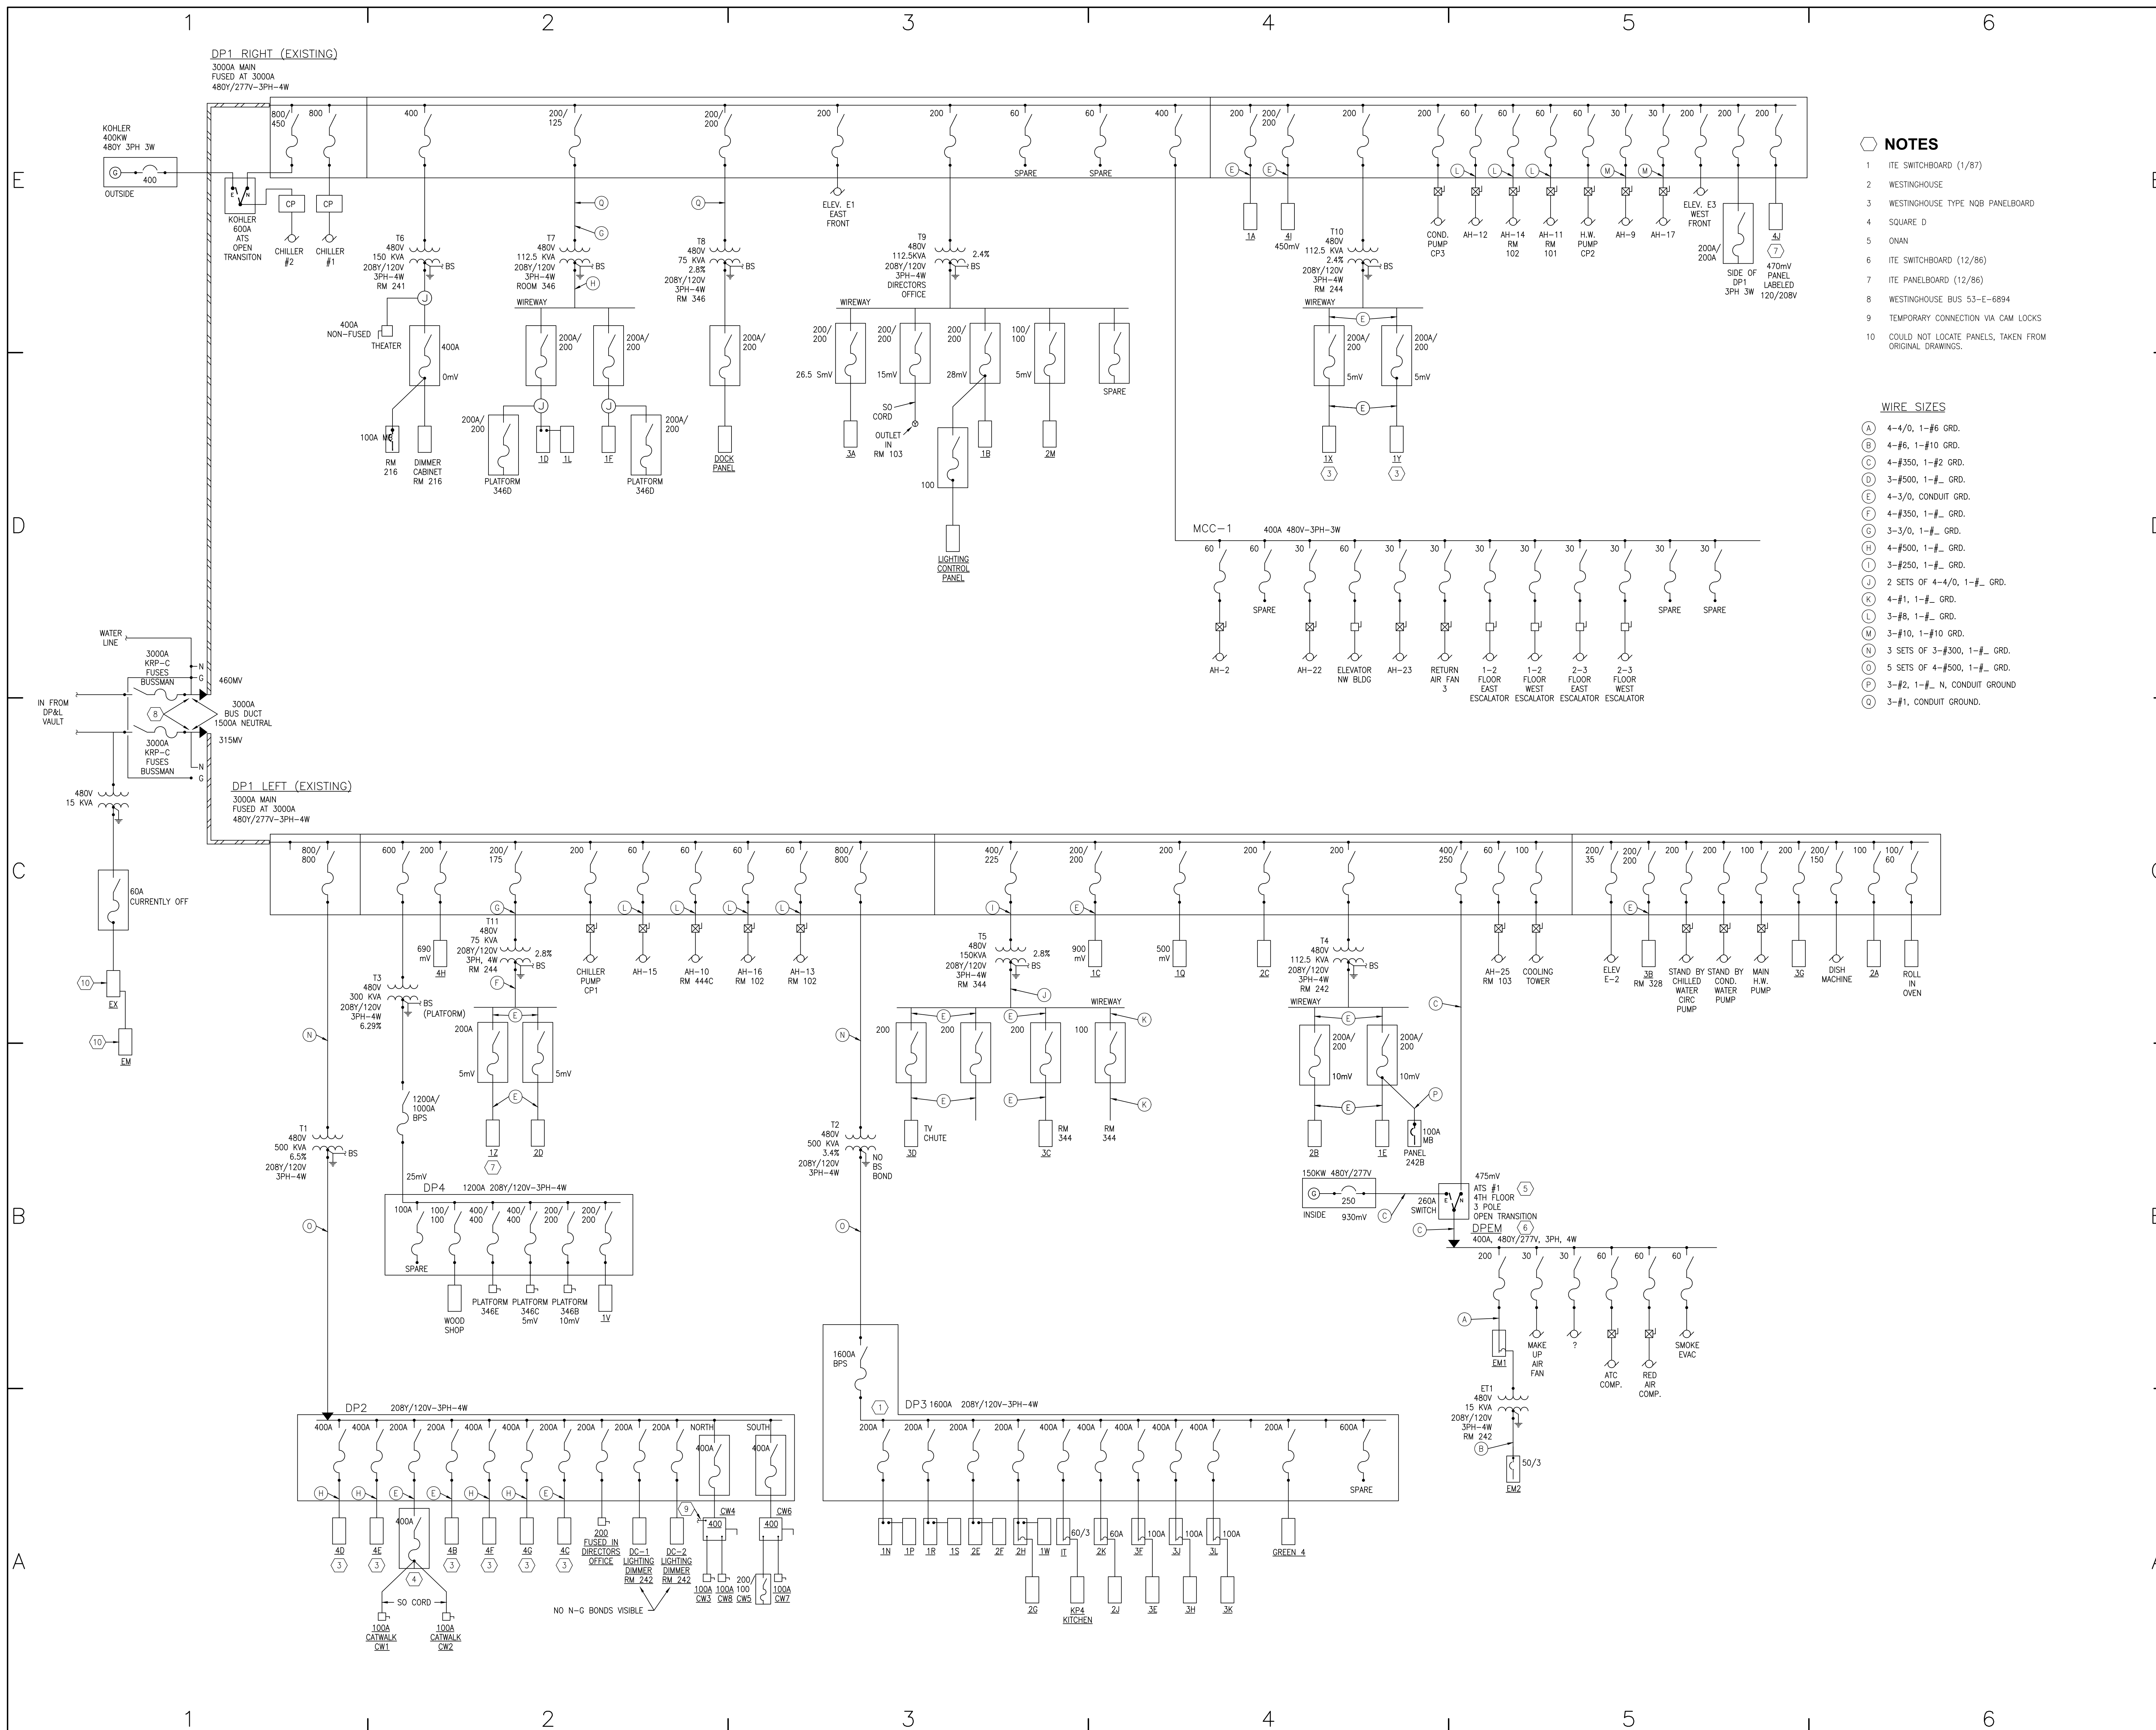

- NOTES**
- ITE SWITCHBOARD (1/87)
 - WESTINGHOUSE
 - WESTINGHOUSE TYPE NOB PANELBOARD
 - SQUARE D
 - ONAN
 - ITE SWITCHBOARD (12/86)
 - ITE PANELBOARD (12/86)
 - WESTINGHOUSE BUS 53-E-6894
 - TEMPORARY CONNECTION VIA CAM LOCKS
 - COULD NOT LOCATE PANELS, TAKEN FROM ORIGINAL DRAWINGS.
- WIRE SIZES**
- (A) 4-4/0, 1-#6 GRD.
 - (B) 4-#6, 1-#10 GRD.
 - (C) 4-#350, 1-#2 GRD.
 - (D) 3-#500, 1-#_ GRD.
 - (E) 4-3/0, CONDUIT GRD.
 - (F) 4-#350, 1-#_ GRD.
 - (G) 3-3/0, 1-#_ GRD.
 - (H) 4-#500, 1-#_ GRD.
 - (I) 3-#250, 1-#_ GRD.
 - (J) 2 SETS OF 4-4/0, 1-#_ GRD.
 - (K) 4-#1, 1-#_ GRD.
 - (L) 3-#8, 1-#_ GRD.
 - (M) 3-#10, 1-#10 GRD.
 - (N) 3 SETS OF 3-#300, 1-#_ GRD.
 - (O) 5 SETS OF 4-#500, 1-#_ GRD.
 - (P) 3-#2, 1-#_ N, CONDUIT GROUND
 - (Q) 3-#1, CONDUIT GROUND.

CONSULTANTS

Heapy Engineering
MEP Design Technology Planning Commissioning Energy
Nationally Recognized Leader in Sustainability
1400 W Dorothy Lane, Dayton, OH 45409-1310
Ph 937-224-0661 Fax 937-224-5777 www.heapy.com

DAYTON CONVENTION CENTER
NEUTRAL ANALYSIS

OWNER
DAYTON CONVENTION & VISITORS BUREAU
1 CHAMBER PLAZA, SUITE A
DAYTON, OHIO 45402

PROJECT NO:	2017-07081
CAD DWG FILE:	ES-1 SINGLELINE DIAGRAM.DWG
DRAWN BY:	-
CHK'D BY:	-
COPYRIGHT:	-

SHEET TITLE
SINGLELINE DIAGRAM

E5.1
SHEET

PROJECT NO: 2017-07081
HEAPY ENGINEERING
DAYTON/COLUMBUS, OHIO & INDIANAPOLIS, INDIANA
MECHANICAL ELECTRICAL COMMISSIONING TECHNOLOGY

DATE: December 20, 2017