



COOLING TOWER TANK DETAIL
SCALE AS NOTED

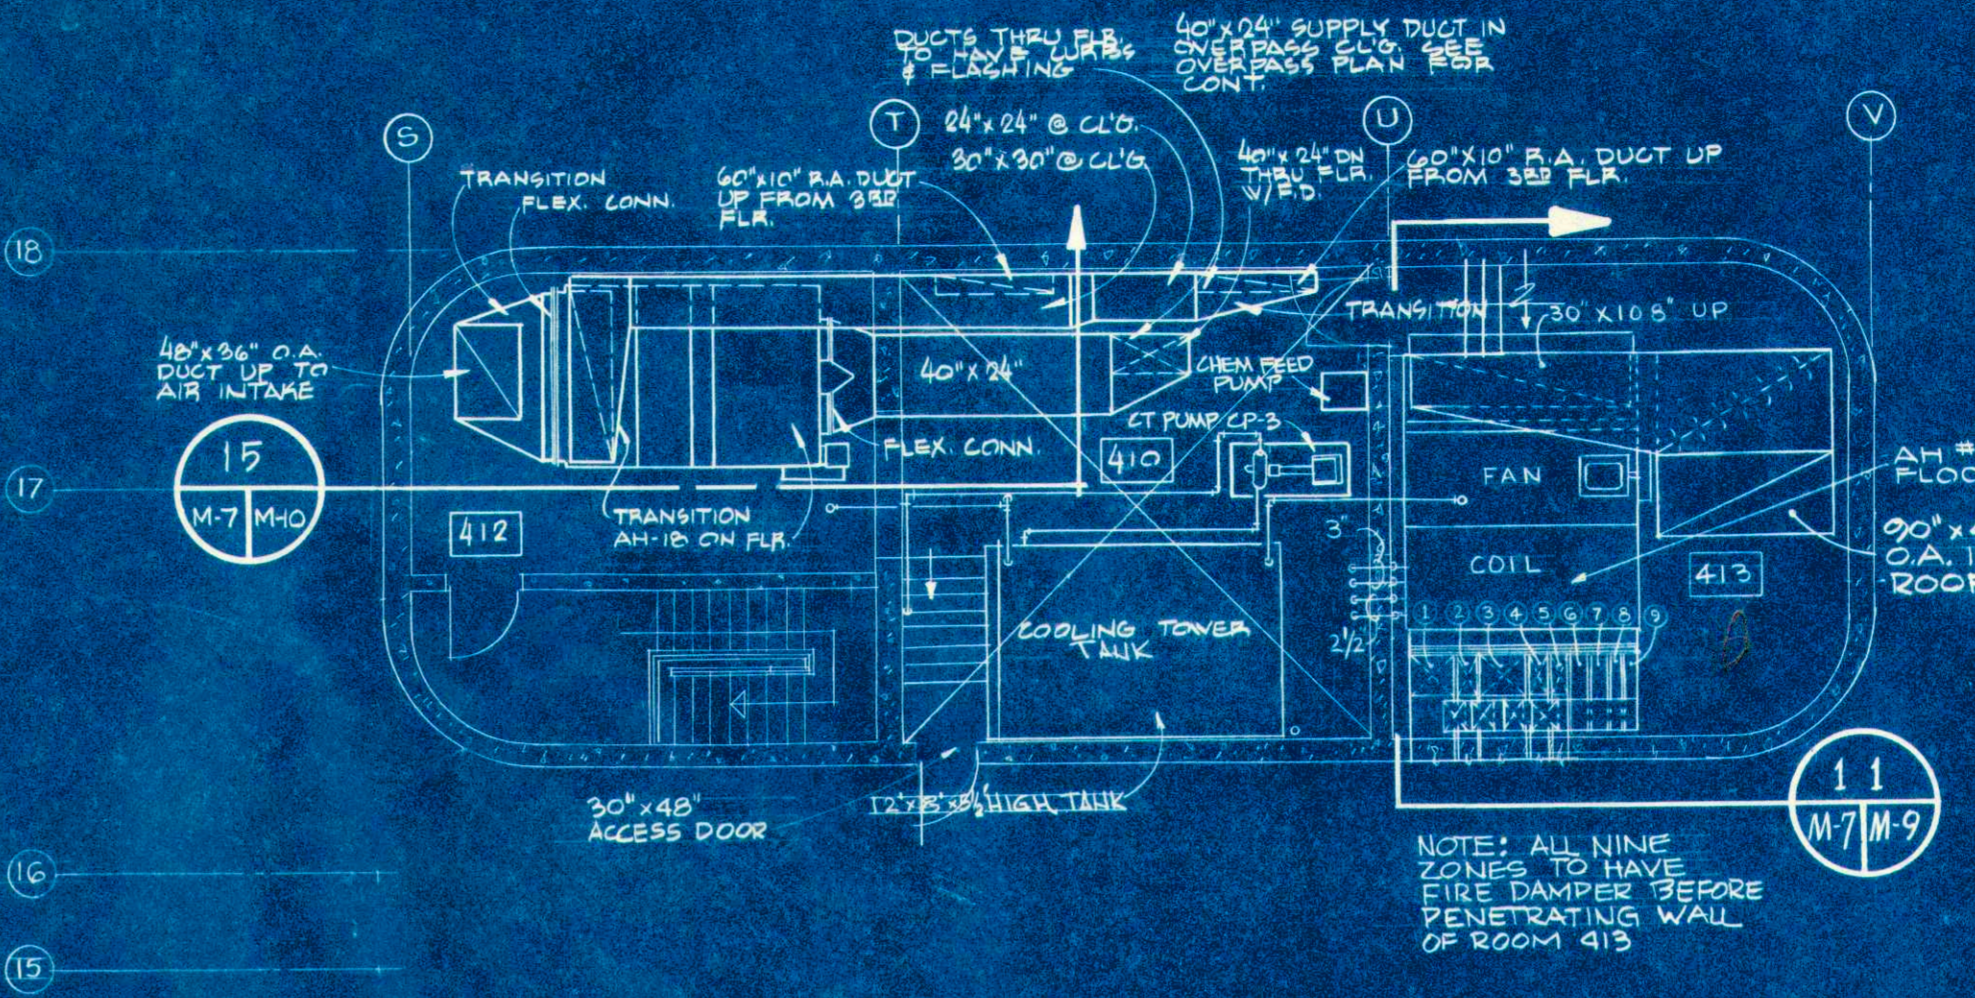


FOURTH FLOOR TOWER AREA
1/8" = 1'-0"

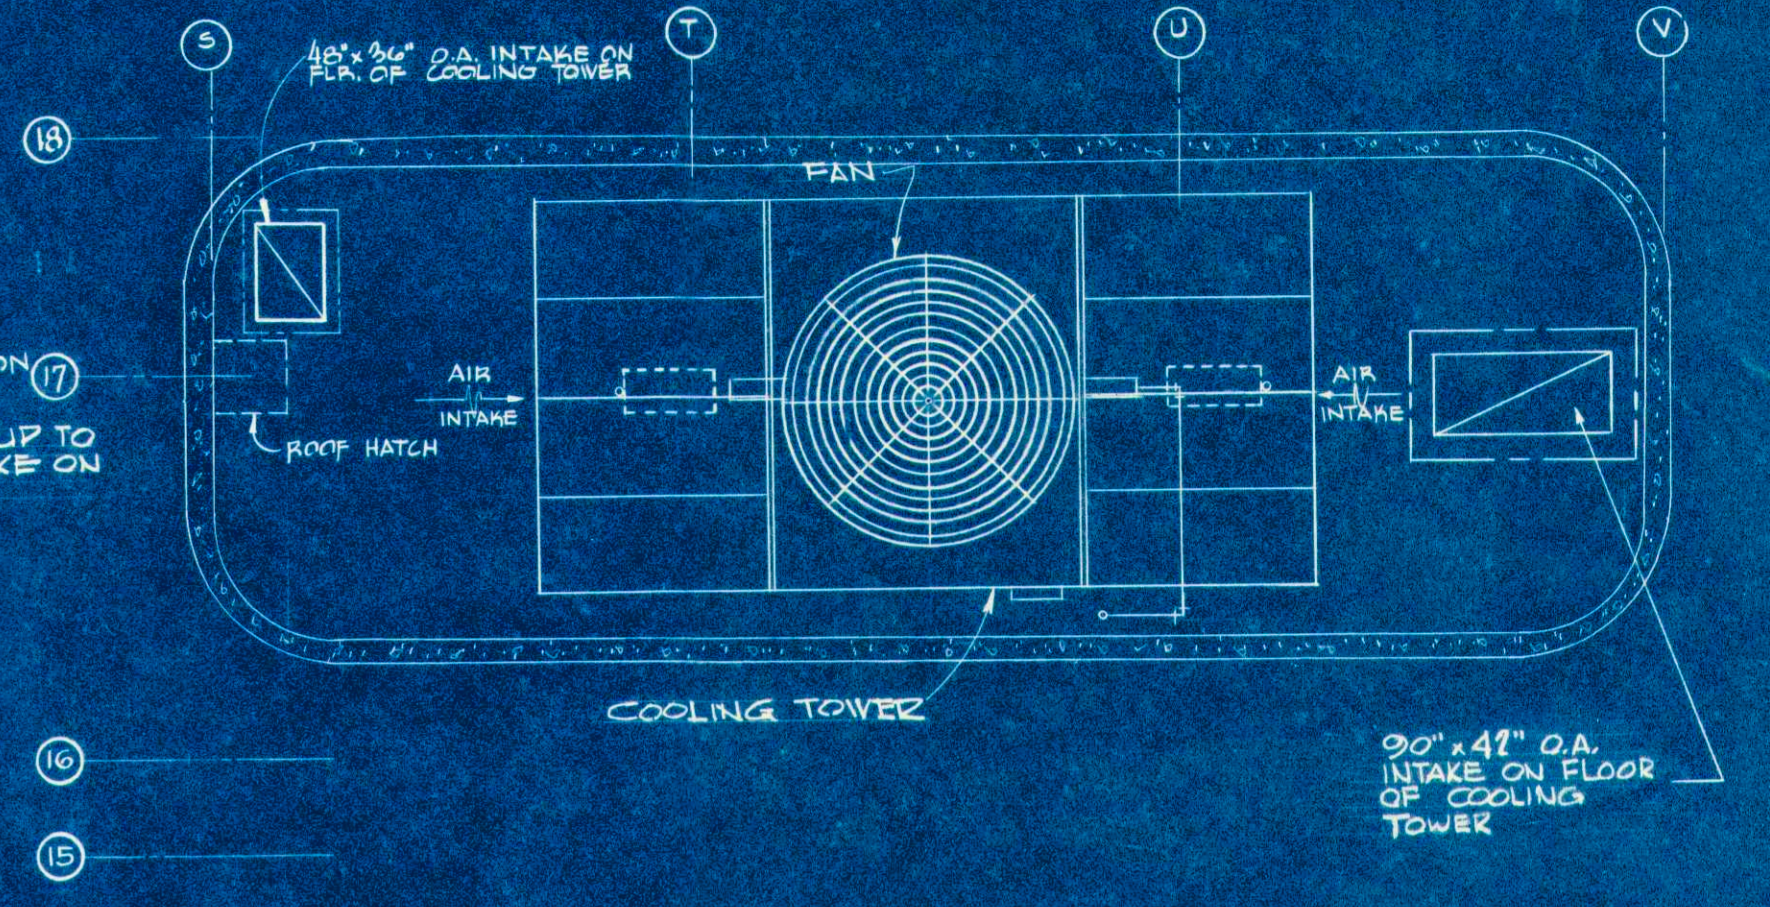


COOLING TOWER FLOOR PLAN
1/8" = 1'-0"

CHEMICAL FEED PUMP ISOMETRIC
NO SCALE

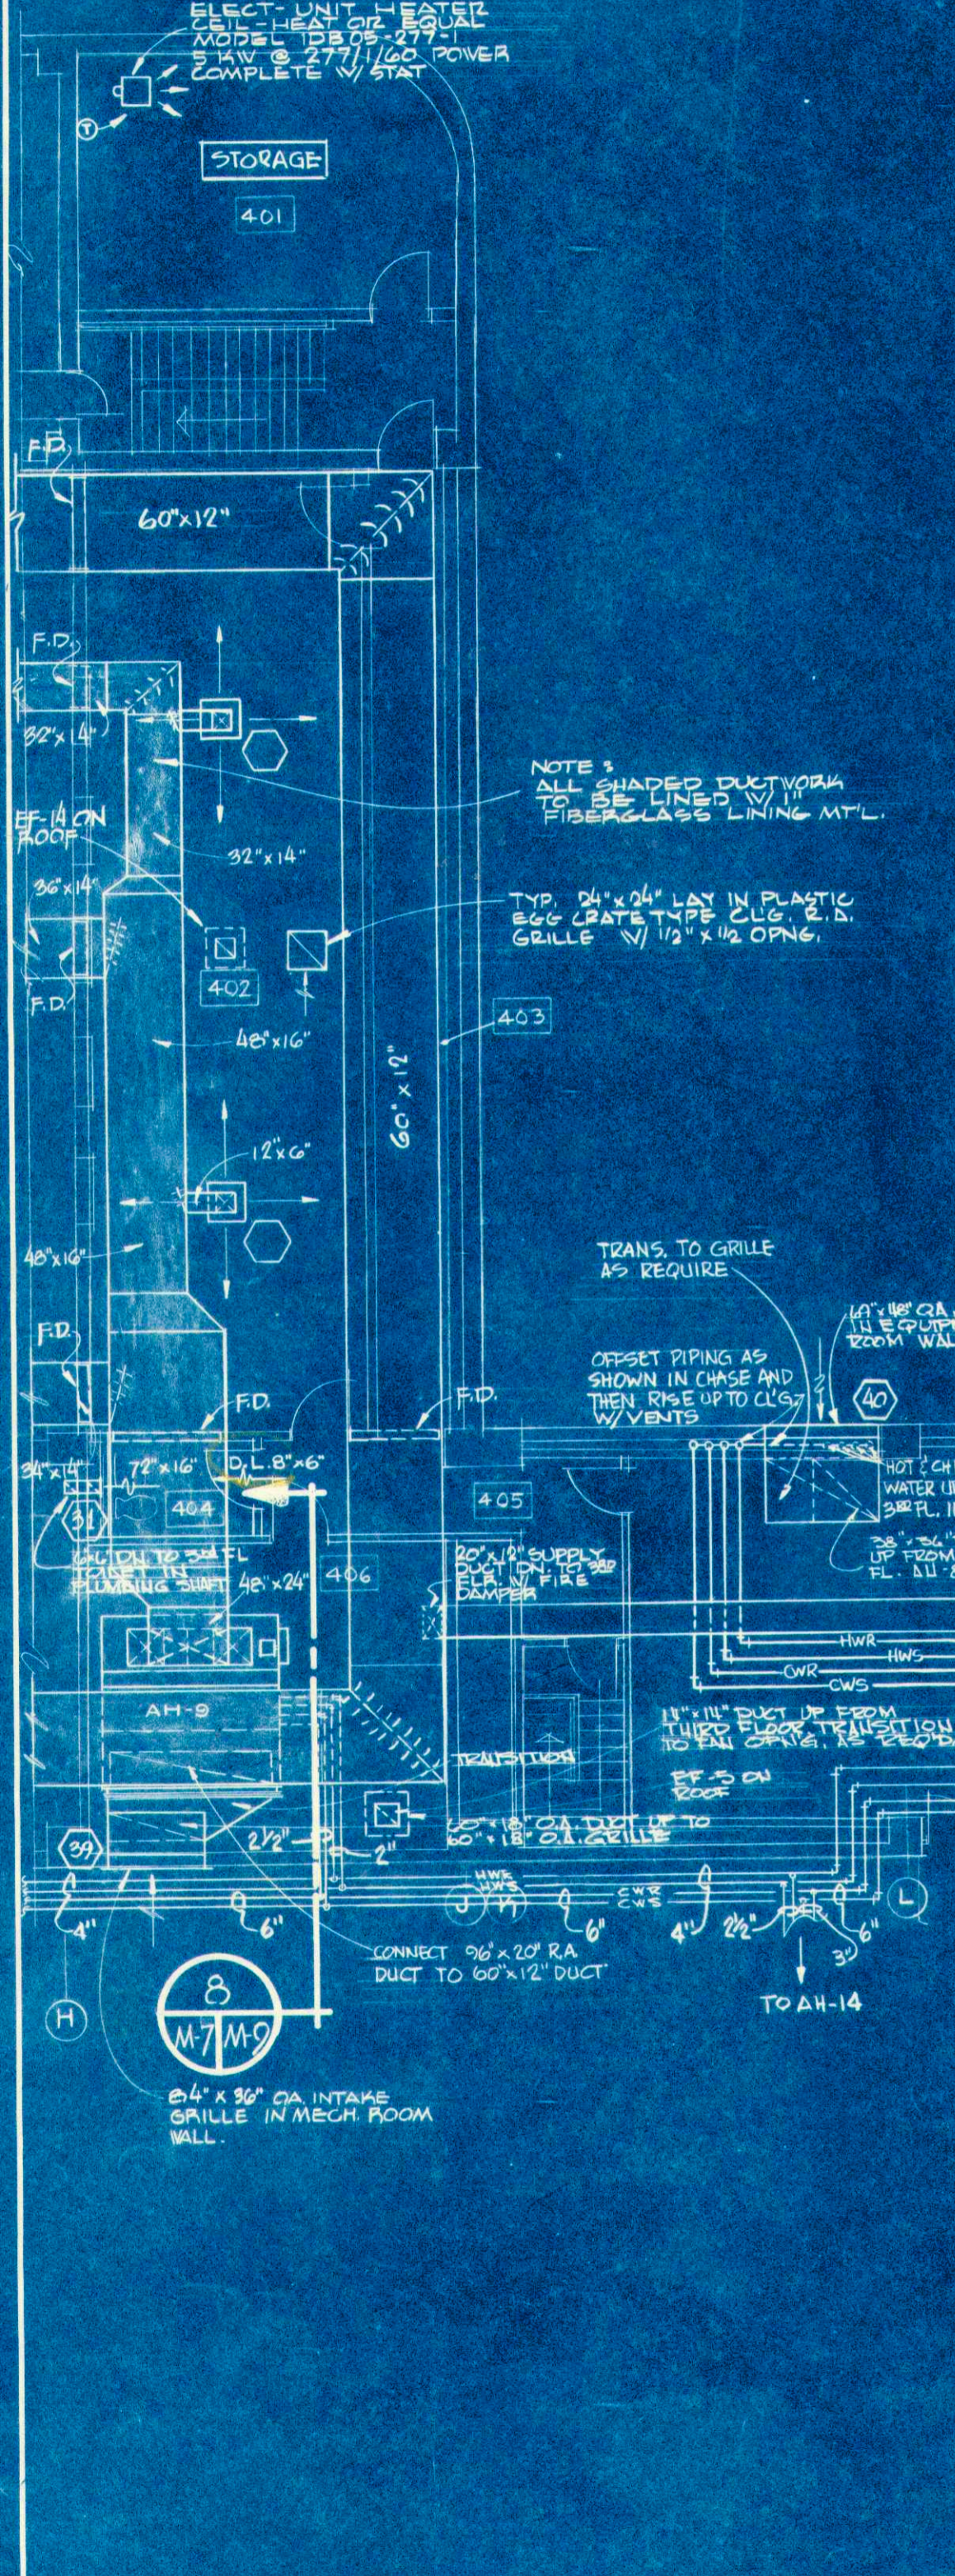

FOURTH FLOOR PLAN-EQUIPMENT ROOM
1/8" = 1'-0"

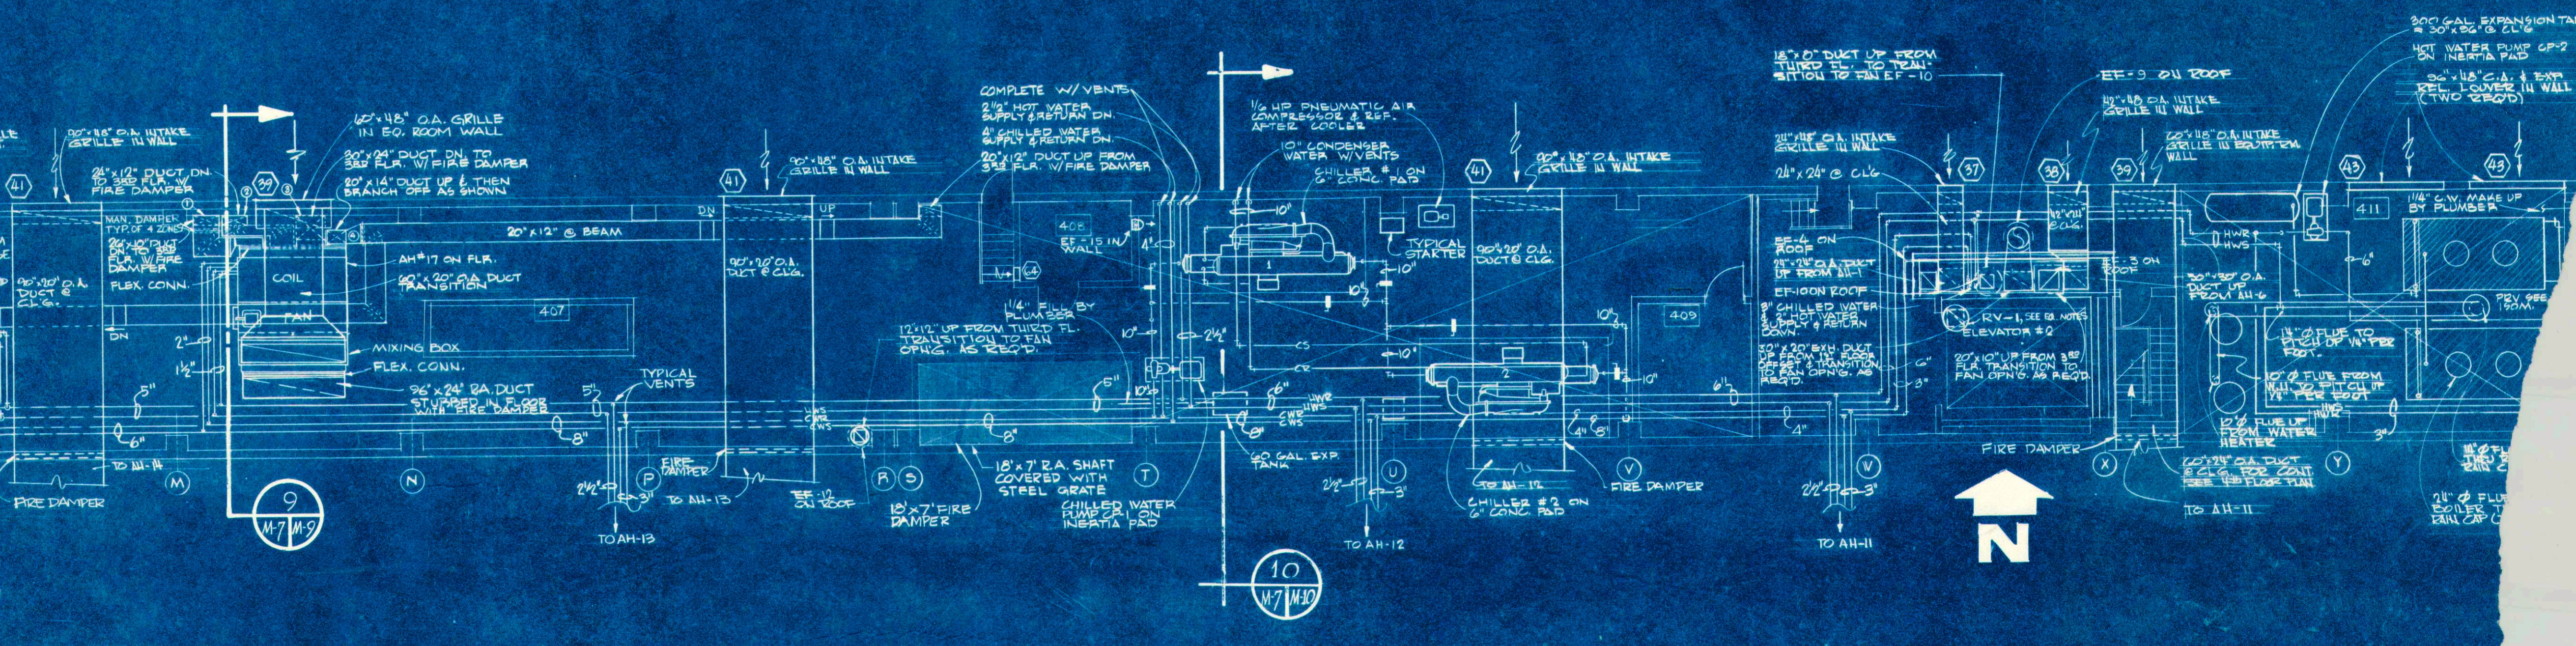

	DENEAU, KLESKI & ASSOCIATES ARCHITECTS 40 W. FOURTH ST. - SUITE 2100 - DAYTON, OHIO		DAYTON EXHIBITION CENTER 5 MAIN STREETS FIFTHYON OHIO	
	DATE: 11-12-70 COMM. NO.: 68007 SHEET NO.: M-7		DRAWN BY: SDG CHECKED: PS	
	REVISIONS NO. DATE BY DESCRIPTION		DATE: 11-13-70 PRINT DATE: Dec. 3, 1970	